


© 2022 ANDY'S BEST CAD. ALL RIGHTS RESERVED. THIS DRAWING IS THE PROPERTY OF ANDY'S BEST CAD AND IS PROTECTED BY COPYRIGHT LAWS OF THE UNITED STATES OF AMERICA. ANY UNAUTHORIZED USE OF THE INFORMATION CONTAINED HEREIN OR PART THEREOF IS STRICTLY PROHIBITED. RECEIPT OR POSSESSION THEREOF DOES NOT CONVEY OR TRANSFER ANY RIGHT TO MAKE, COPY, MANUFACTURE AND/OR SELL EITHER THE DRAWING OR THE ITEMS SHOWN THEREON.

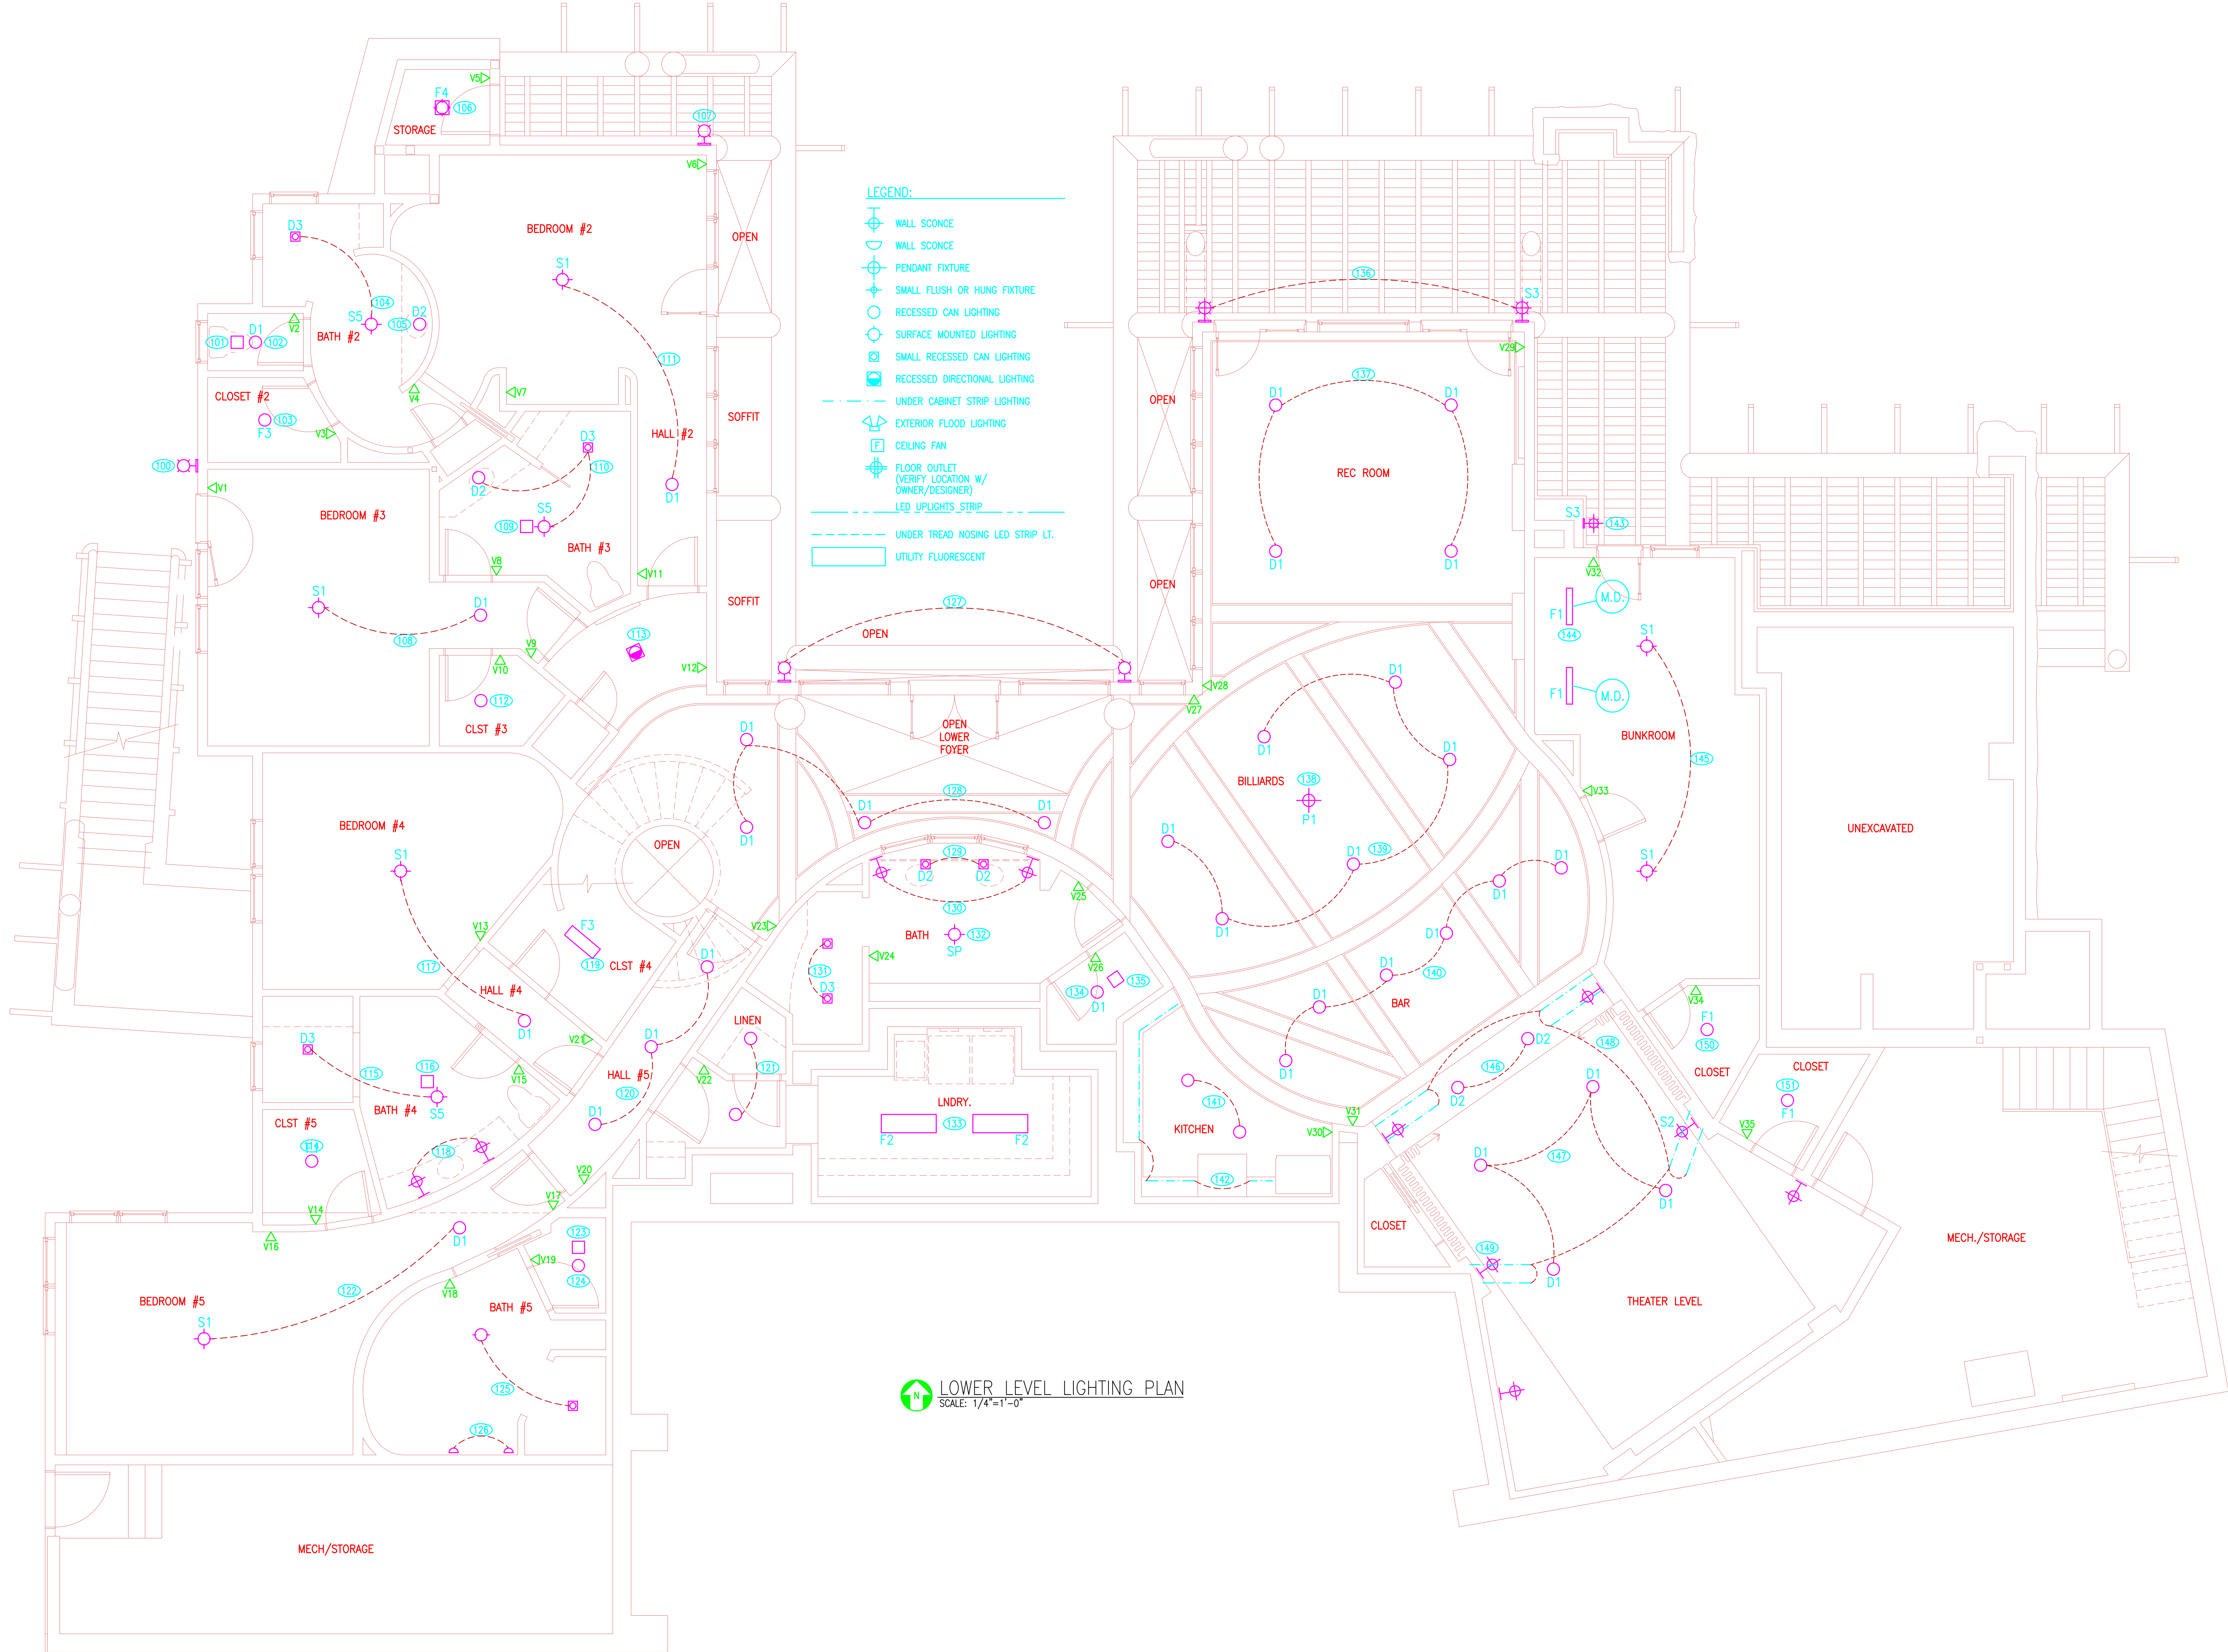

LOWER LEVEL LIGHTING PLAN
SCALE: 1/4"=1'-0"

DRAWING TITLE:	LOWER LEVEL LIGHTING PLAN
DRAWING NO.:	E101 of
PROJECT:	CUSTOM RESIDENTIAL HOME LIGHTING PLANS CONSTRUCTION DRAWINGS
DRAWN:	ABC
DESIGNED:	ABC
CLIENT:	ANDY'S BEST CAD 1323 CARLYLE PARK CIRCLE HIGHLANDS RANCH, CO 80129 303-808-3352 WWW.ANDYSBESTCAD.COM
DATE:	03/18/22
SCALE:	1/4"=1'-0"
REVISION DESCRIPTION:	
DATE:	

