



©2022 ANDY'S BEST CAD. ALL RIGHTS RESERVED. THIS DRAWING IS THE PROPERTY OF ANDY'S BEST CAD AND IS PROTECTED BY COPYRIGHT LAWS OF THE UNITED STATES OF AMERICA. ANY UNAUTHORIZED USE OF THE INFORMATION CONTAINED HEREIN OR PART THEREOF IS STRICTLY PROHIBITED. RECEIPT OR POSSESSION THEREOF DOES NOT CONVEY OR TRANSFER ANY RIGHT TO MAKE, COPY, MANUFACTURE AND/OR SELL EITHER THE DRAWING OR THE ITEMS SHOWN THEREON.

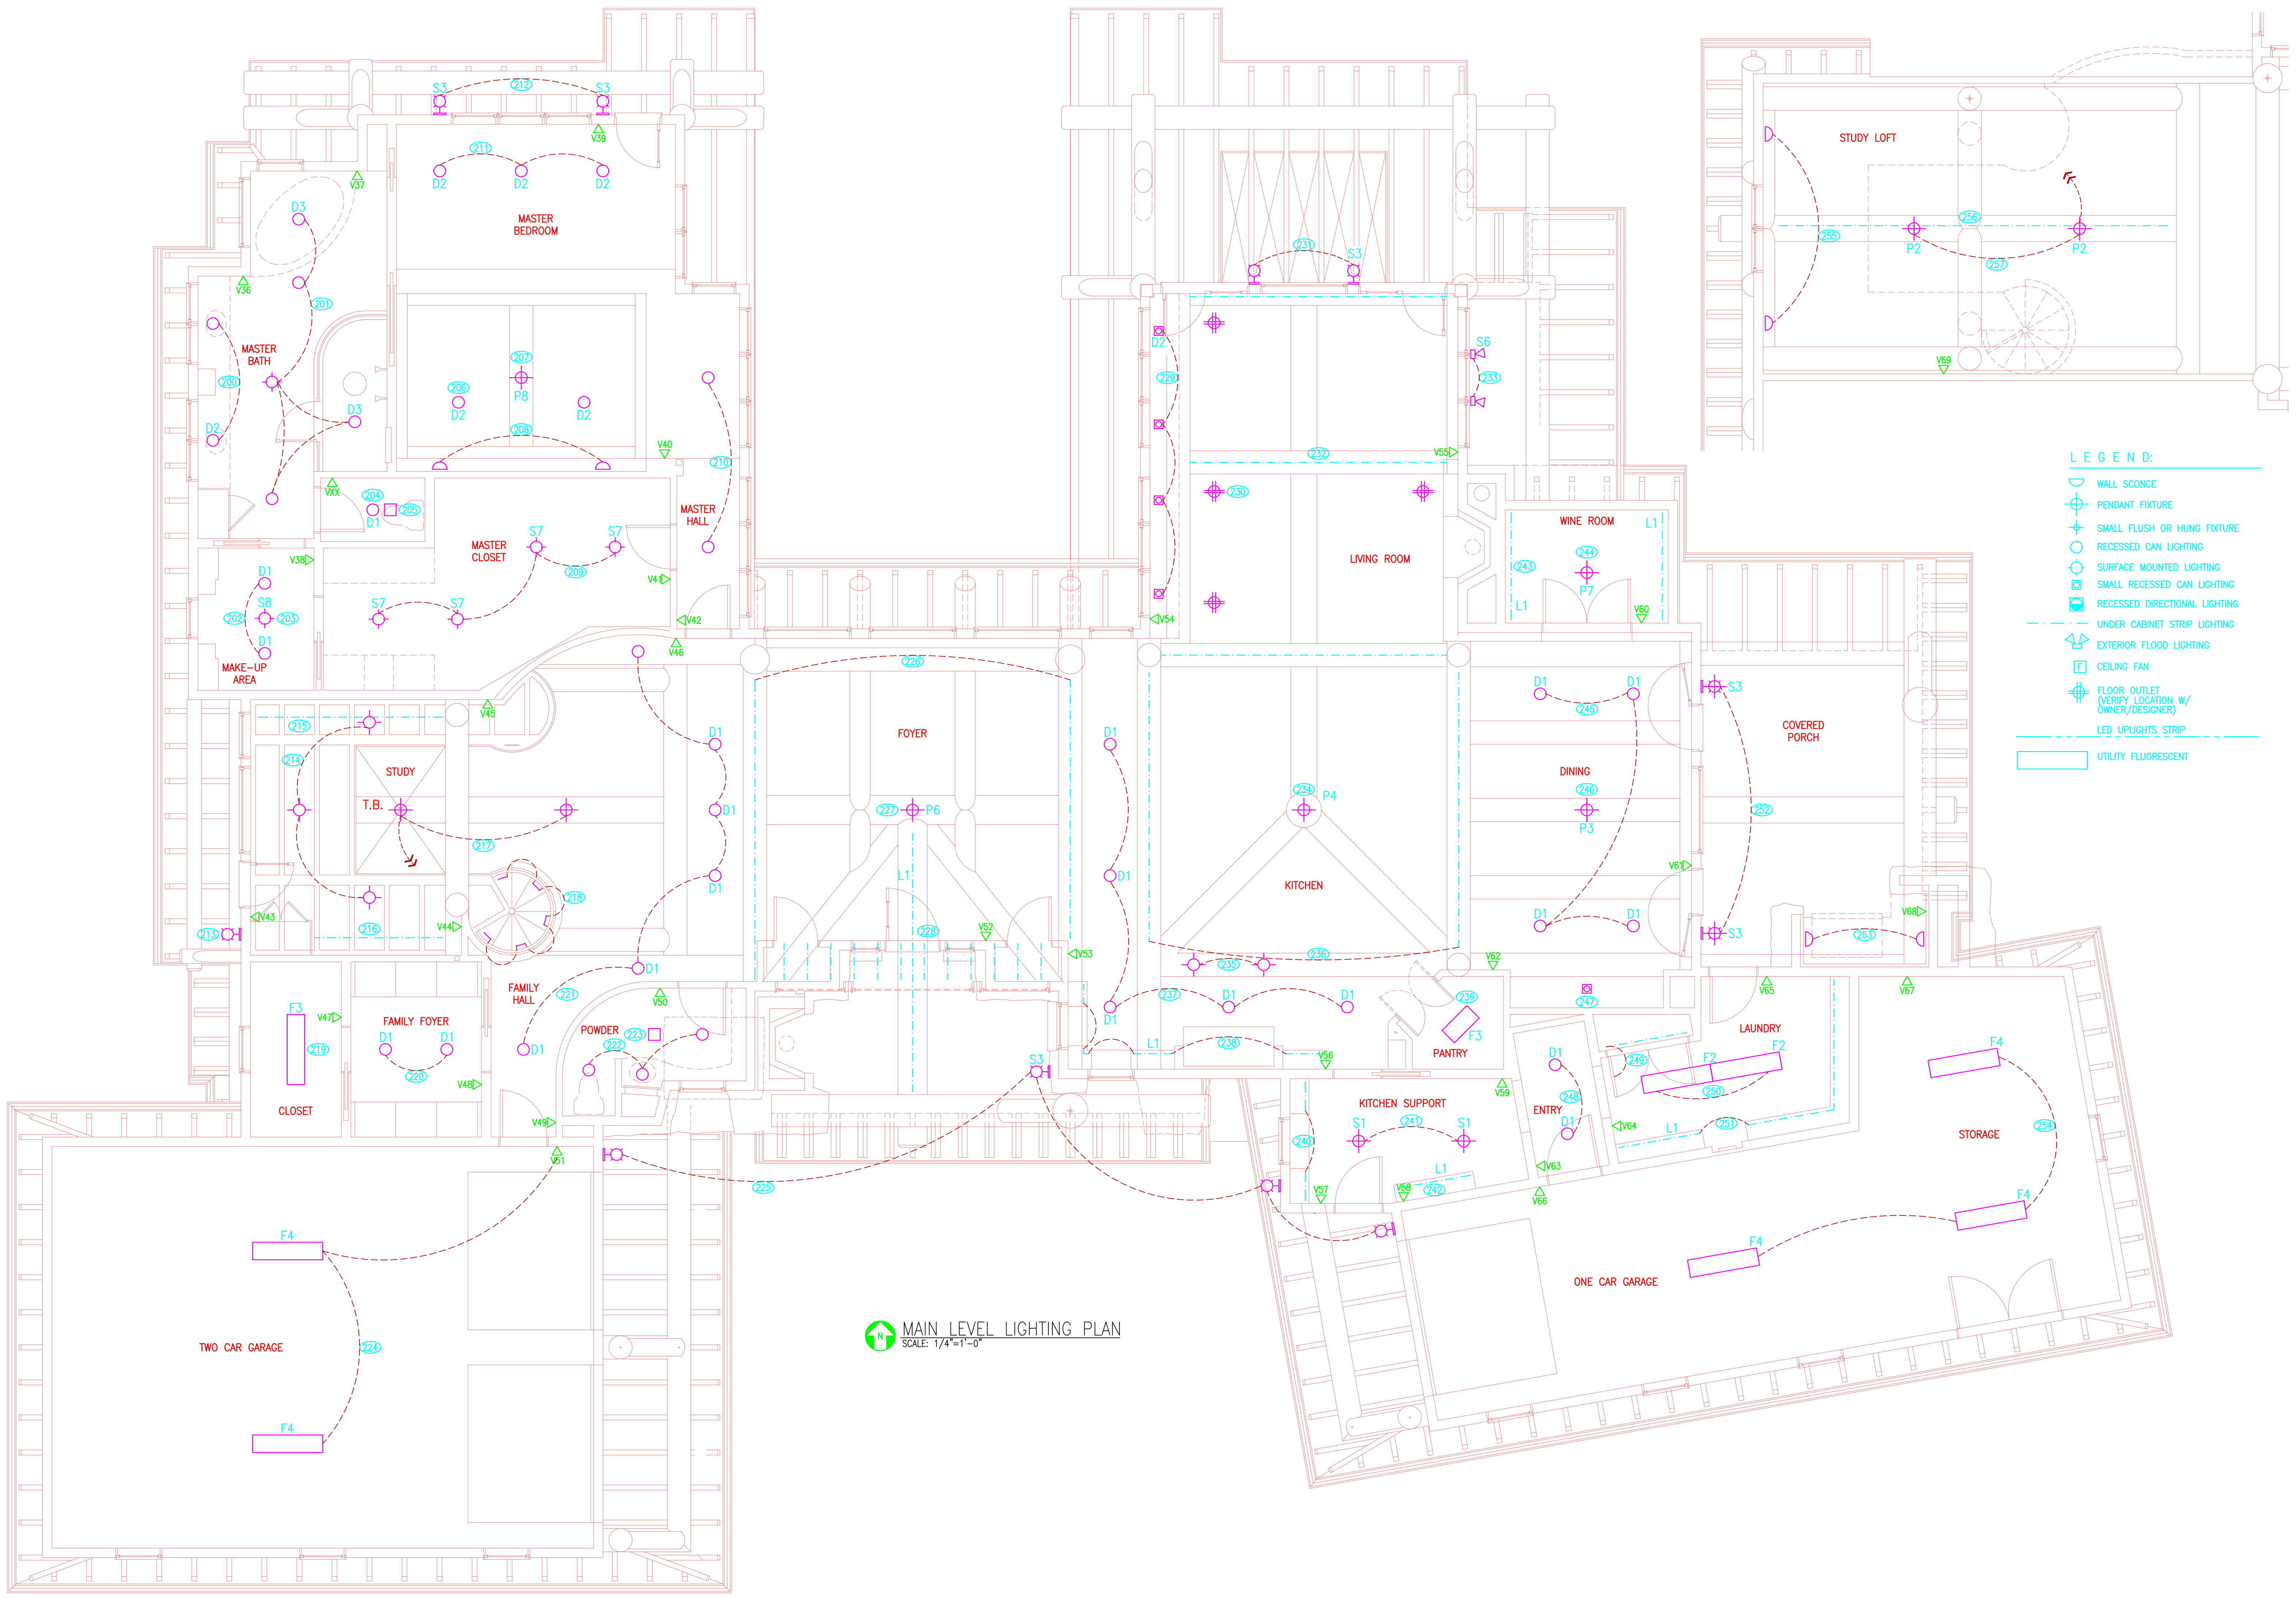

REV#	REVISION DESCRIPTION	DATE

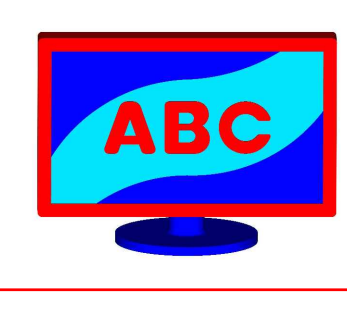

ANDY'S BEST CAD
 1323 CARLYLE PARK CIRCLE
 HIGHLANDS RANCH, CO 80129
 303-808-3352
 WWW.ANDYSBESTCAD.COM

DRAWN: ABC
 DESIGNED:
 CLIENT: 03/18/22
 DATE: 1/4"=1'-0"
 SCALE:

PROJECT:
 CUSTOM RESIDENTIAL HOME
 LIGHTING PLANS
 CONSTRUCTION DRAWINGS

DRAWING TITLE:
 MAIN LEVEL LIGHTING PLAN

DRAWING NO:
 E102
 of