



3RD FLOOR NEW MECHANICAL PLAN
SCALE: 1/4"=1'-0"

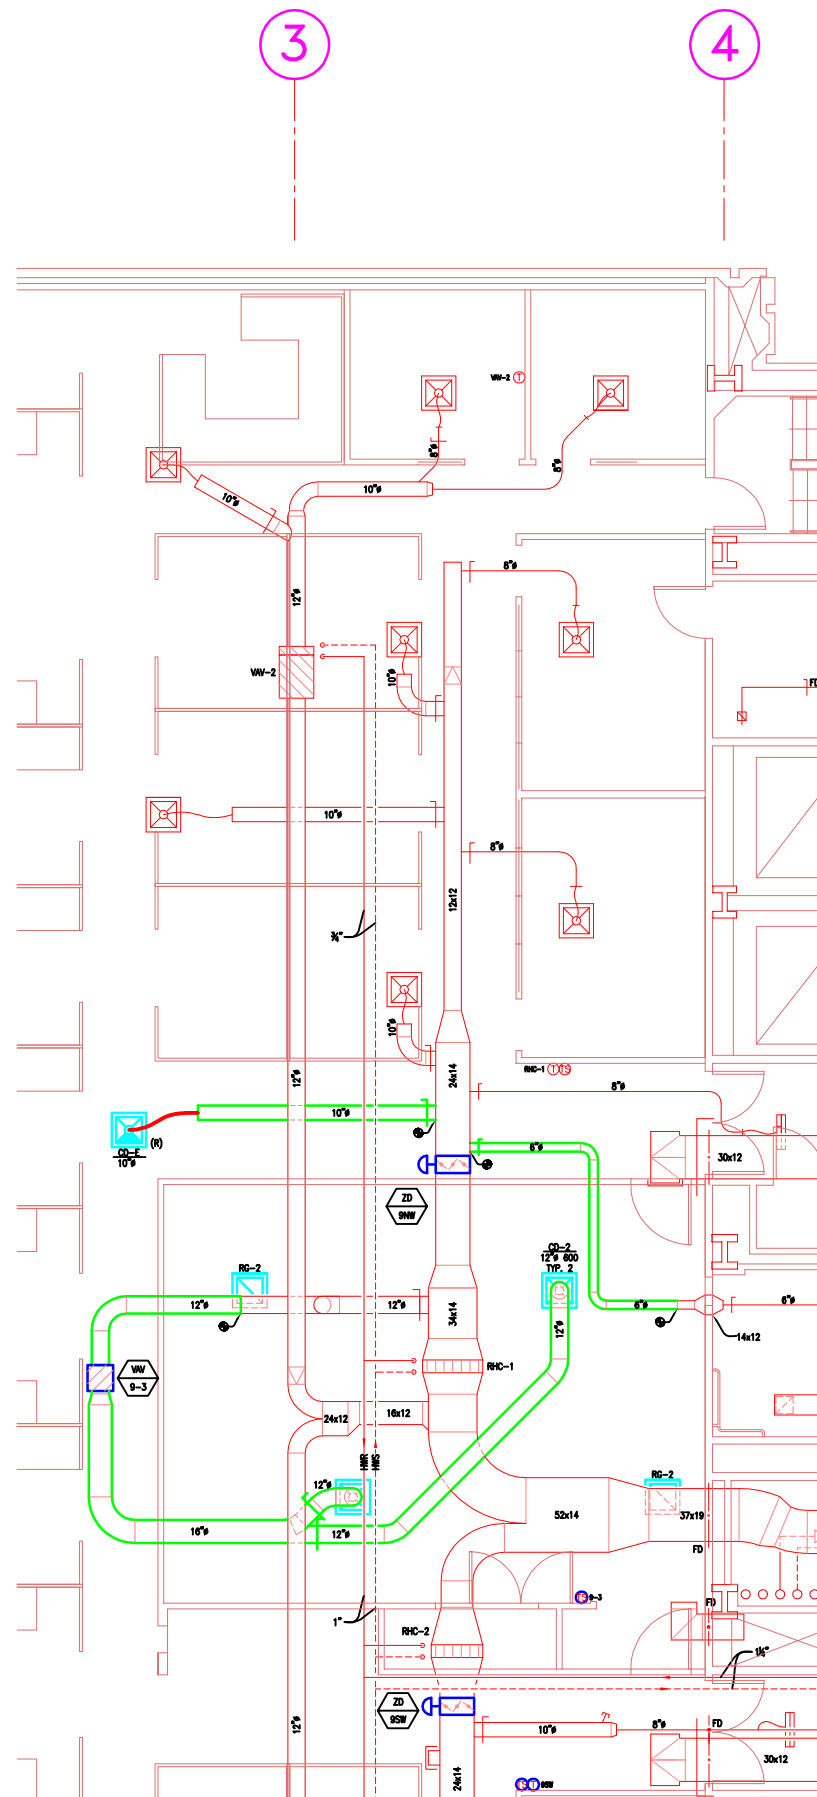

9TH FLOOR NEW MECHANICAL PLAN
SCALE: 1/4"=1'-0"

ABC NO. JOB NO. DATE DATE

Andy's Best CAD
9715 South Merimbula Street
Littleton, Colorado 80130
303-791-1622
andysbestcad@yahoo.com
www.andysbestcad.com

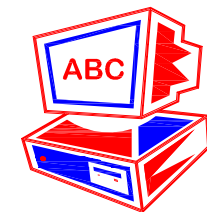

ISSUE:

NO.	DATE:	ISSUE:

DRAWN: ALANDT
DESIGNED:
CHECKED:
CLIENT JOB NO.:
DATE: 08/03/04
FILE: ABC-303-0308-M21.dwg

DRAWING TITLE:
**3RD & 9TH FLOORS
NEW
MECHANICAL PLAN**

DRAWING NUMBER:
M2.1