



© 2022 ANDY'S BEST CAD. ALL RIGHTS RESERVED. THIS DRAWING IS THE PROPERTY OF ANDY'S BEST CAD AND IS PROTECTED BY COPYRIGHT LAWS OF THE UNITED STATES OF AMERICA. ANY UNAUTHORIZED USE OF THE INFORMATION CONTAINED HEREIN OR PART THEREOF IS STRICTLY PROHIBITED. RECEIPT OR POSSESSION THEREOF DOES NOT CONVEY OR TRANSFER ANY RIGHT TO MAKE, COPY, MANUFACTURE AND/OR SELL EITHER THE DRAWING OR THE ITEMS SHOWN THEREON.

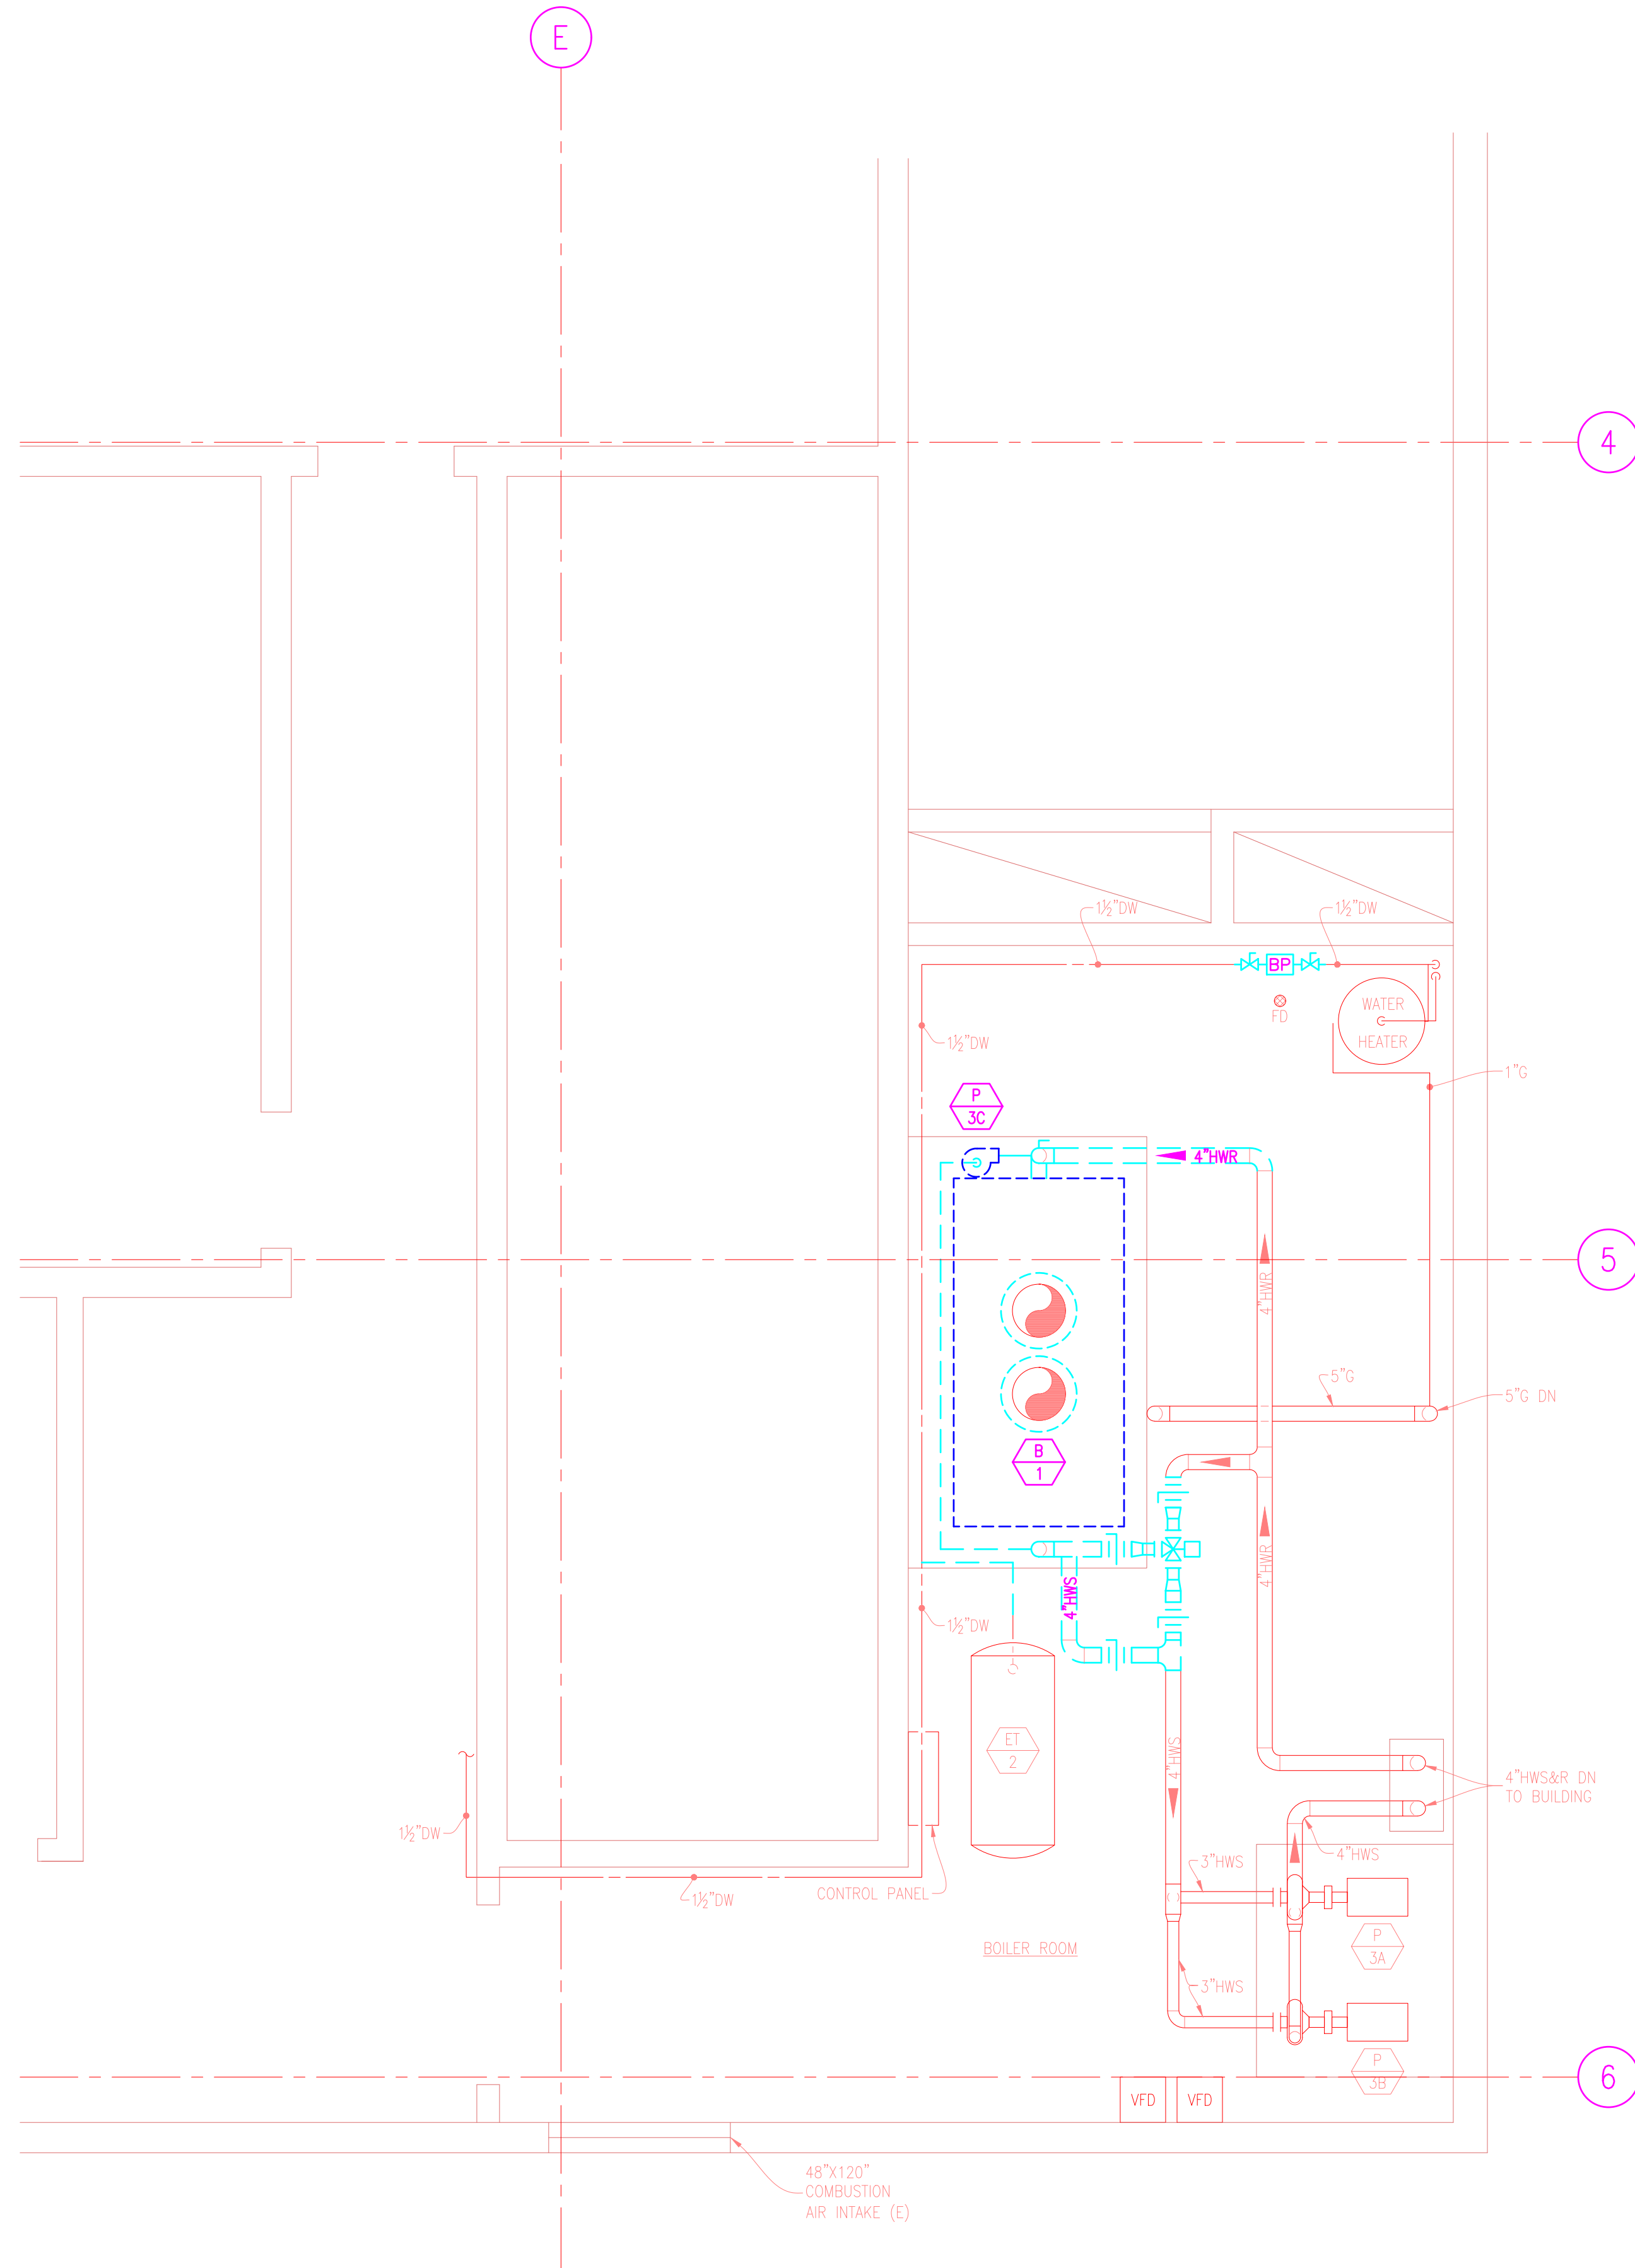

**PARTIAL PENTHOUSE BOILER ROOM DEMOLITION PLAN**  
SCALE: 3/8"=1'-0"

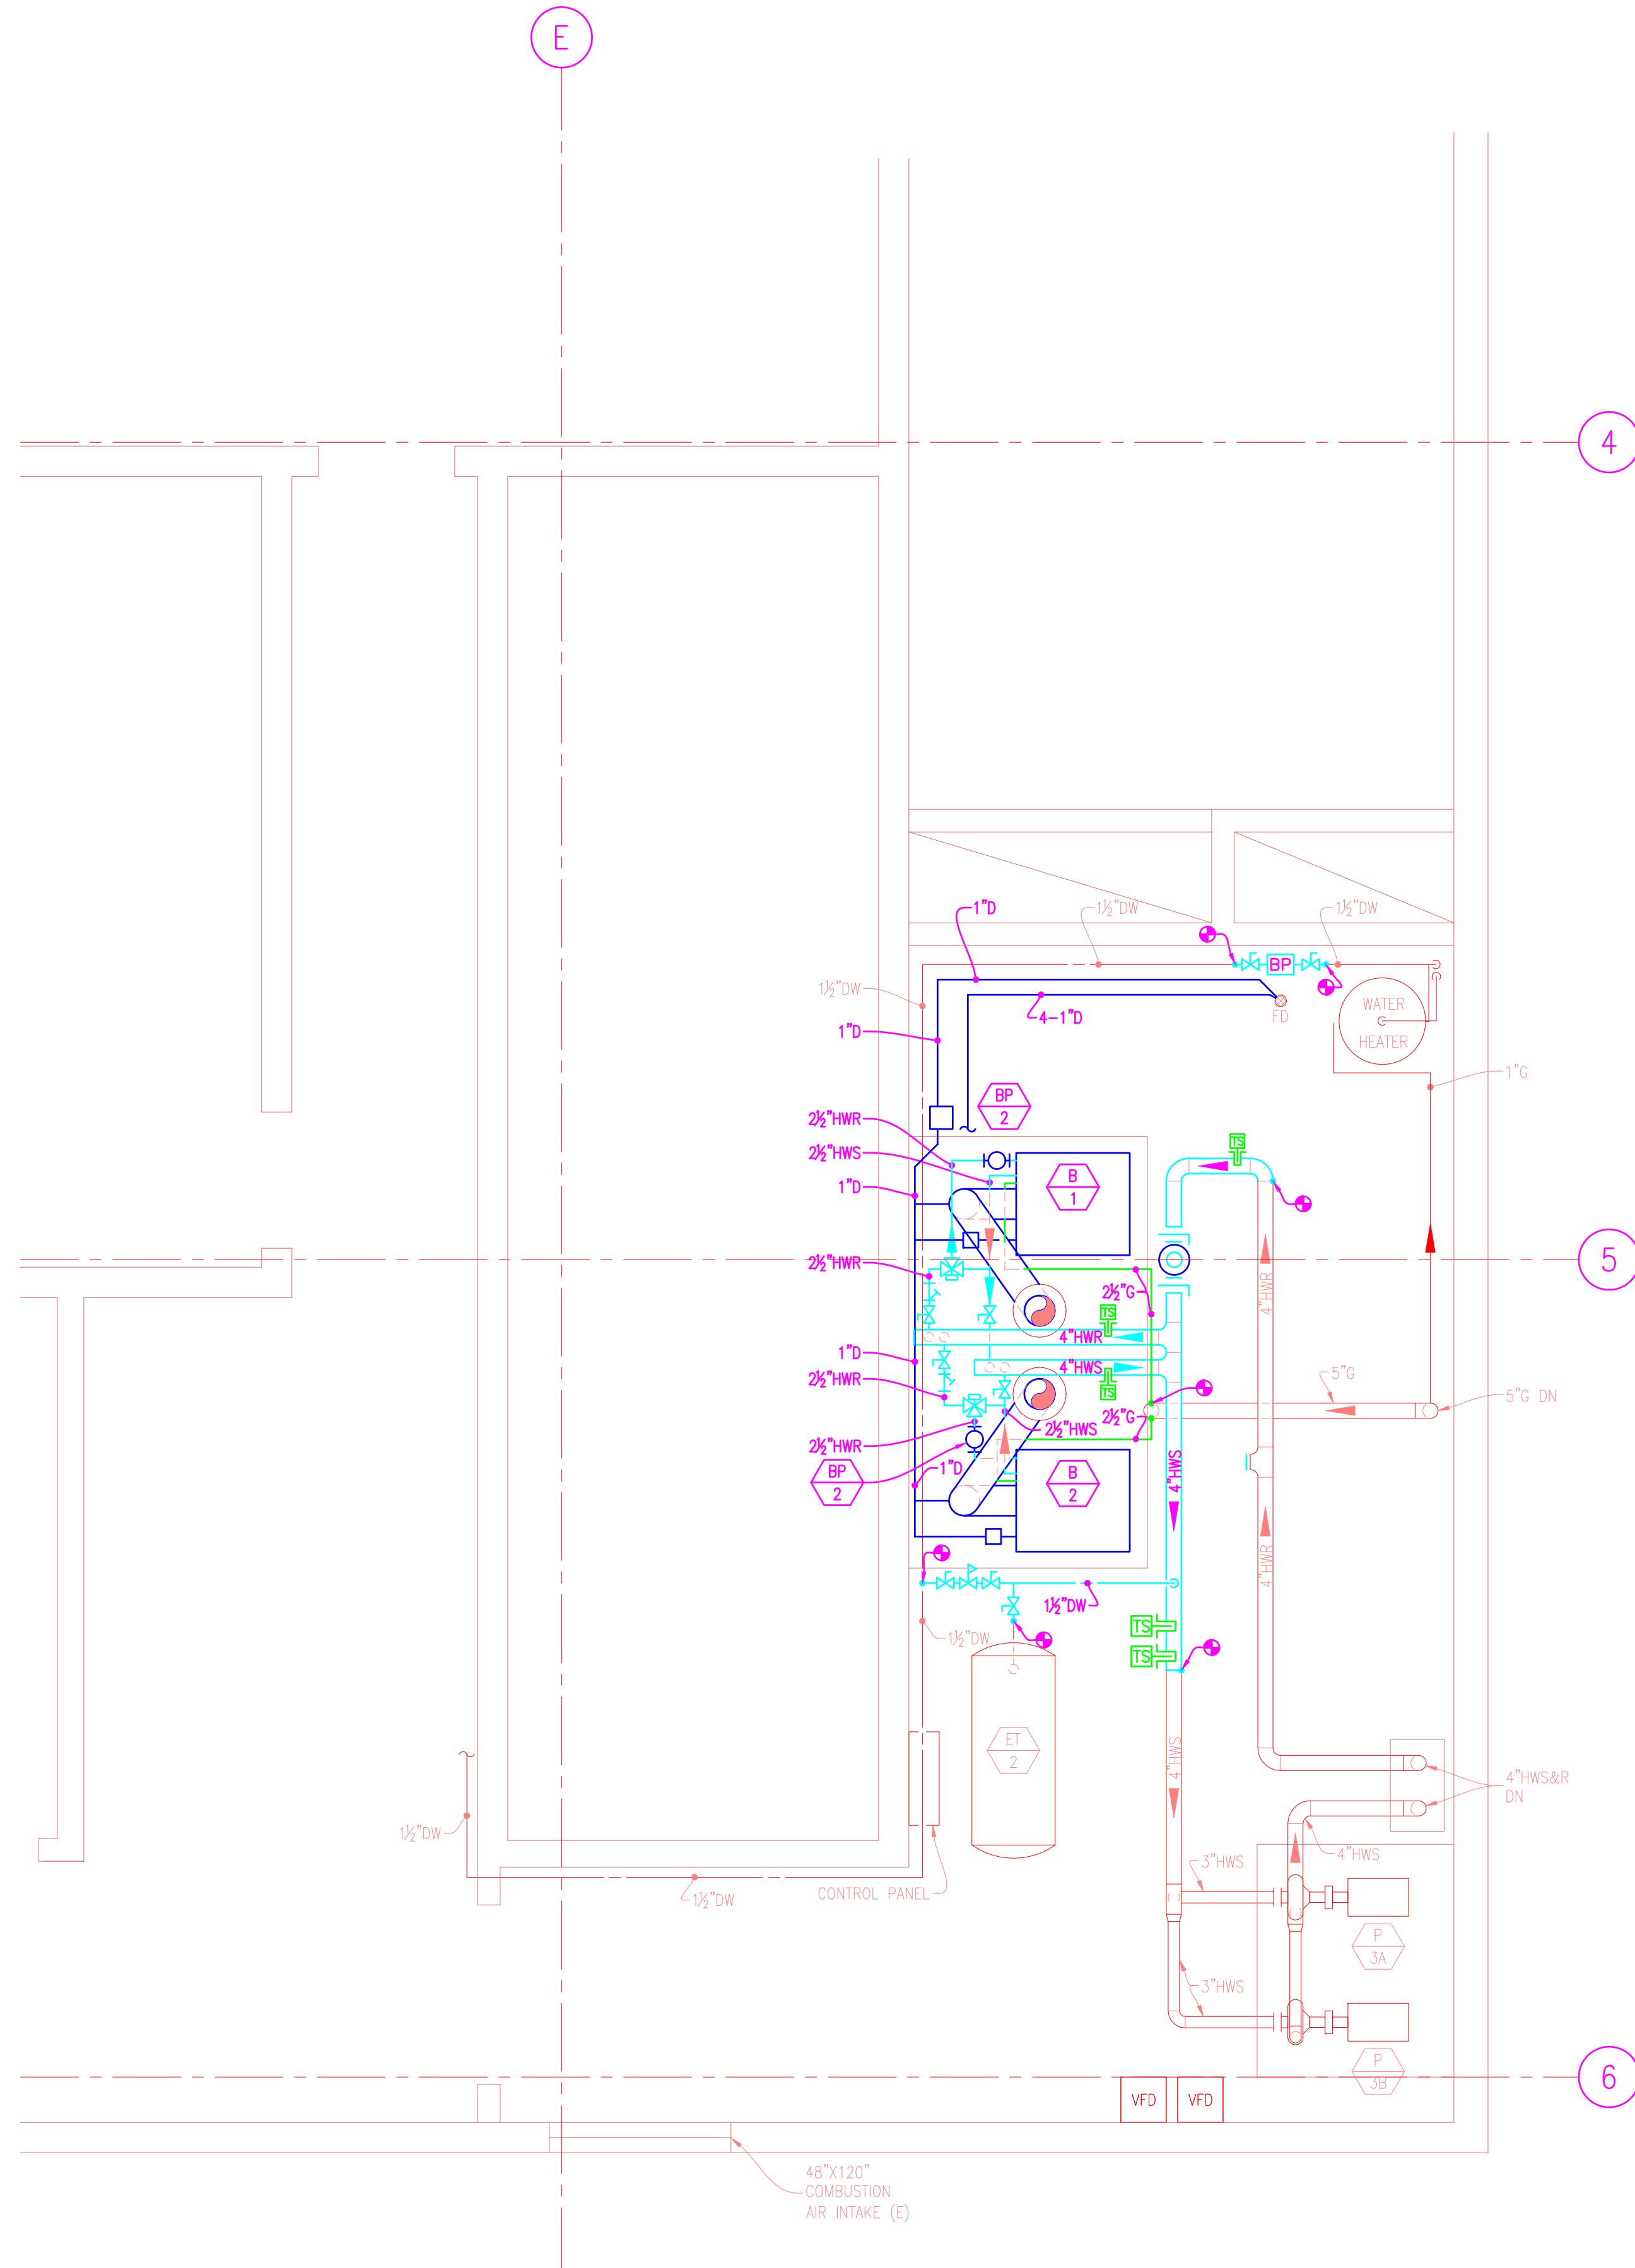

**PARTIAL PENTHOUSE BOILER ROOM NEW MECHANICAL PLAN**  
SCALE: 3/8"=1'-0"

REV#	REVISION DESCRIPTION	DATE

ENGINEER'S STAMP

ANDY'S BEST CAD  
1323 CARLYLE PARK CIRCLE  
HIGHLANDS RANCH, CO 80129  
303-808-3352  
WWW.ANDYSBESTCAD.COM

DRAWN: ABC  
DESIGNED:  
CLIENT: 03/10/22  
DATE: 3/8"=1'-0"  
SCALE:

PROJECT:  
COMMERCIAL OFFICE BUILDING  
BOILER REPLACEMENT  
MECHANICAL  
CONSTRUCTION DRAWINGS

DRAWING TITLE:  
PENTHOUSE BOILER ROOM  
DEMOLITION AND NEW  
MECHANICAL PLANS

DRAWING NO:  
M01  
OF

