


© 2022 ANDY'S BEST CAD. ALL RIGHTS RESERVED. THIS DRAWING IS THE PROPERTY OF ANDY'S BEST CAD AND IS PROTECTED BY COPYRIGHT LAWS OF THE UNITED STATES OF AMERICA. ANY UNAUTHORIZED USE OF THE INFORMATION CONTAINED HEREIN OR PART THEREOF IS STRICTLY PROHIBITED. RECEIPT OR POSSESSION THEREOF DOES NOT CONVEY OR TRANSFER ANY RIGHT TO MAKE, COPY, MANUFACTURE AND/OR SELL EITHER THE DRAWING OR THE ITEMS SHOWN THEREON.

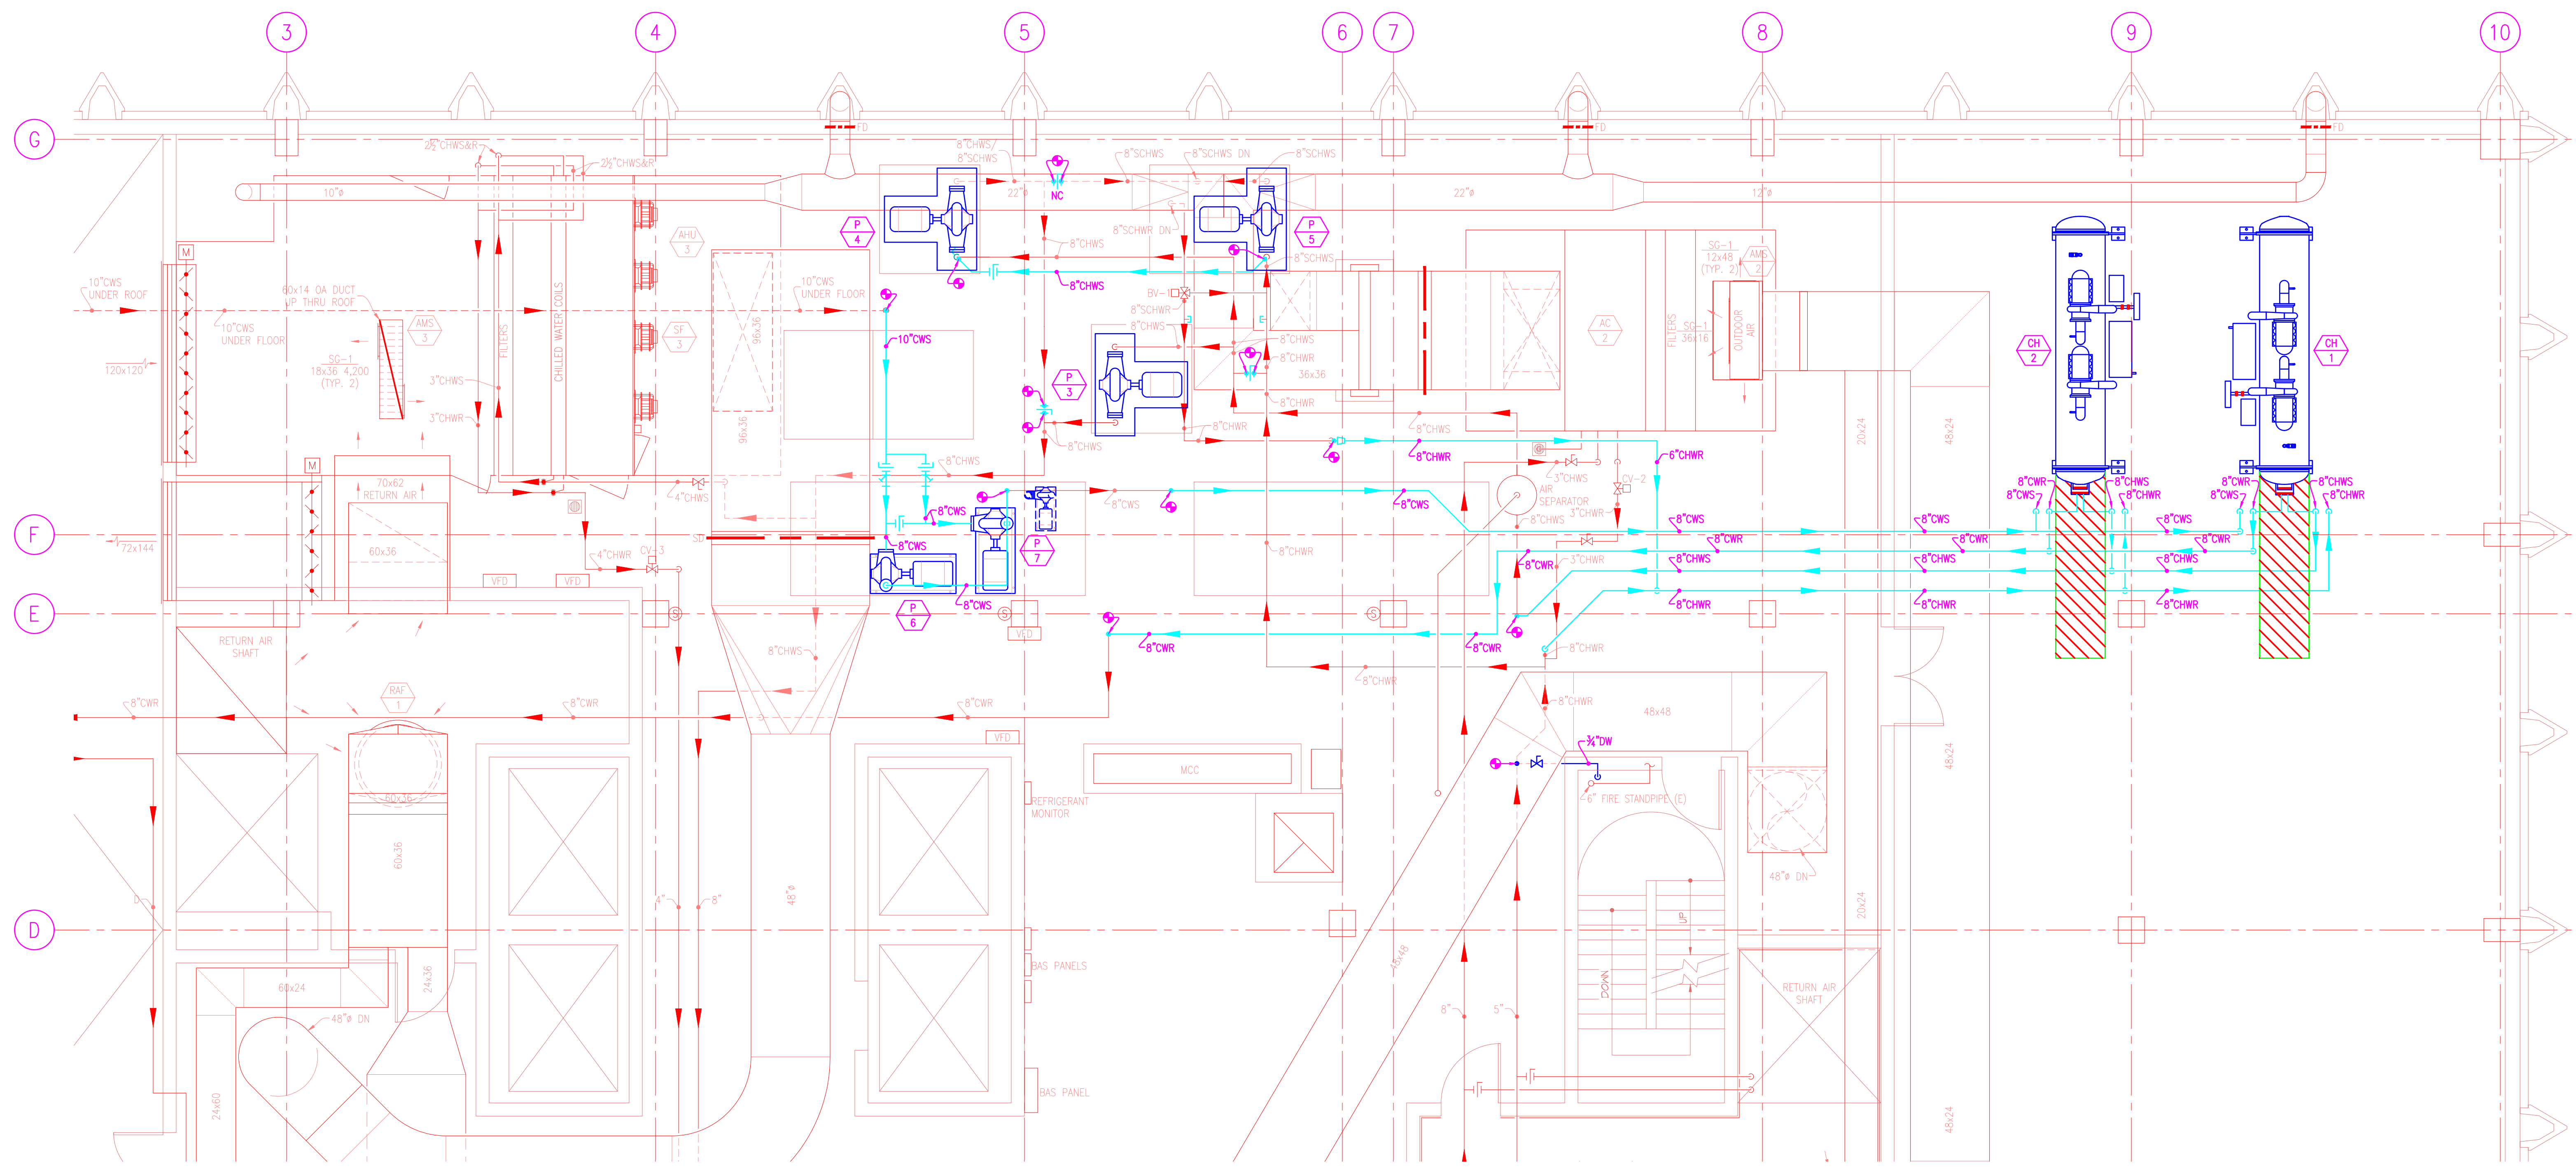

PENTHOUSE PARTIAL NEW MECHANICAL PLAN
SCALE: 1/4"=1'-0"

DATE:	
REVISION DESCRIPTION:	
ENGINEER'S STAMP	
PROJECT:	COMMERCIAL OFFICE BUILDING CHILLER REPLACEMENT MECHANICAL CONSTRUCTION DRAWINGS
DRAWING TITLE:	PENTHOUSE PARTIAL NEW MECHANICAL PLAN
DRAWING NO.:	M02 OF
DRAWN:	ABC
DESIGNED:	ABC
CLIENT:	ANDY'S BEST CAD 1323 CARLYLE PARK CIRCLE HIGHLANDS RANCH, CO 80129 303-808-3352 WWW.ANDYSBESTCAD.COM
DATE:	03/10/22
SCALE:	1/4"=1'-0"