



© 2022 ANDY'S BEST CAD. ALL RIGHTS RESERVED. THIS DRAWING IS THE PROPERTY OF ANDY'S BEST CAD AND IS PROTECTED BY COPYRIGHT LAWS OF THE UNITED STATES OF AMERICA. ANY UNAUTHORIZED USE OF THE INFORMATION CONTAINED HEREIN OR PART THEREOF IS STRICTLY PROHIBITED. RECEIPT OR POSSESSION THEREOF DOES NOT CONVEY OR TRANSFER ANY RIGHT TO MAKE, COPY, MANUFACTURE AND/OR SELL EITHER THE DRAWING OR THE ITEMS SHOWN THEREON.

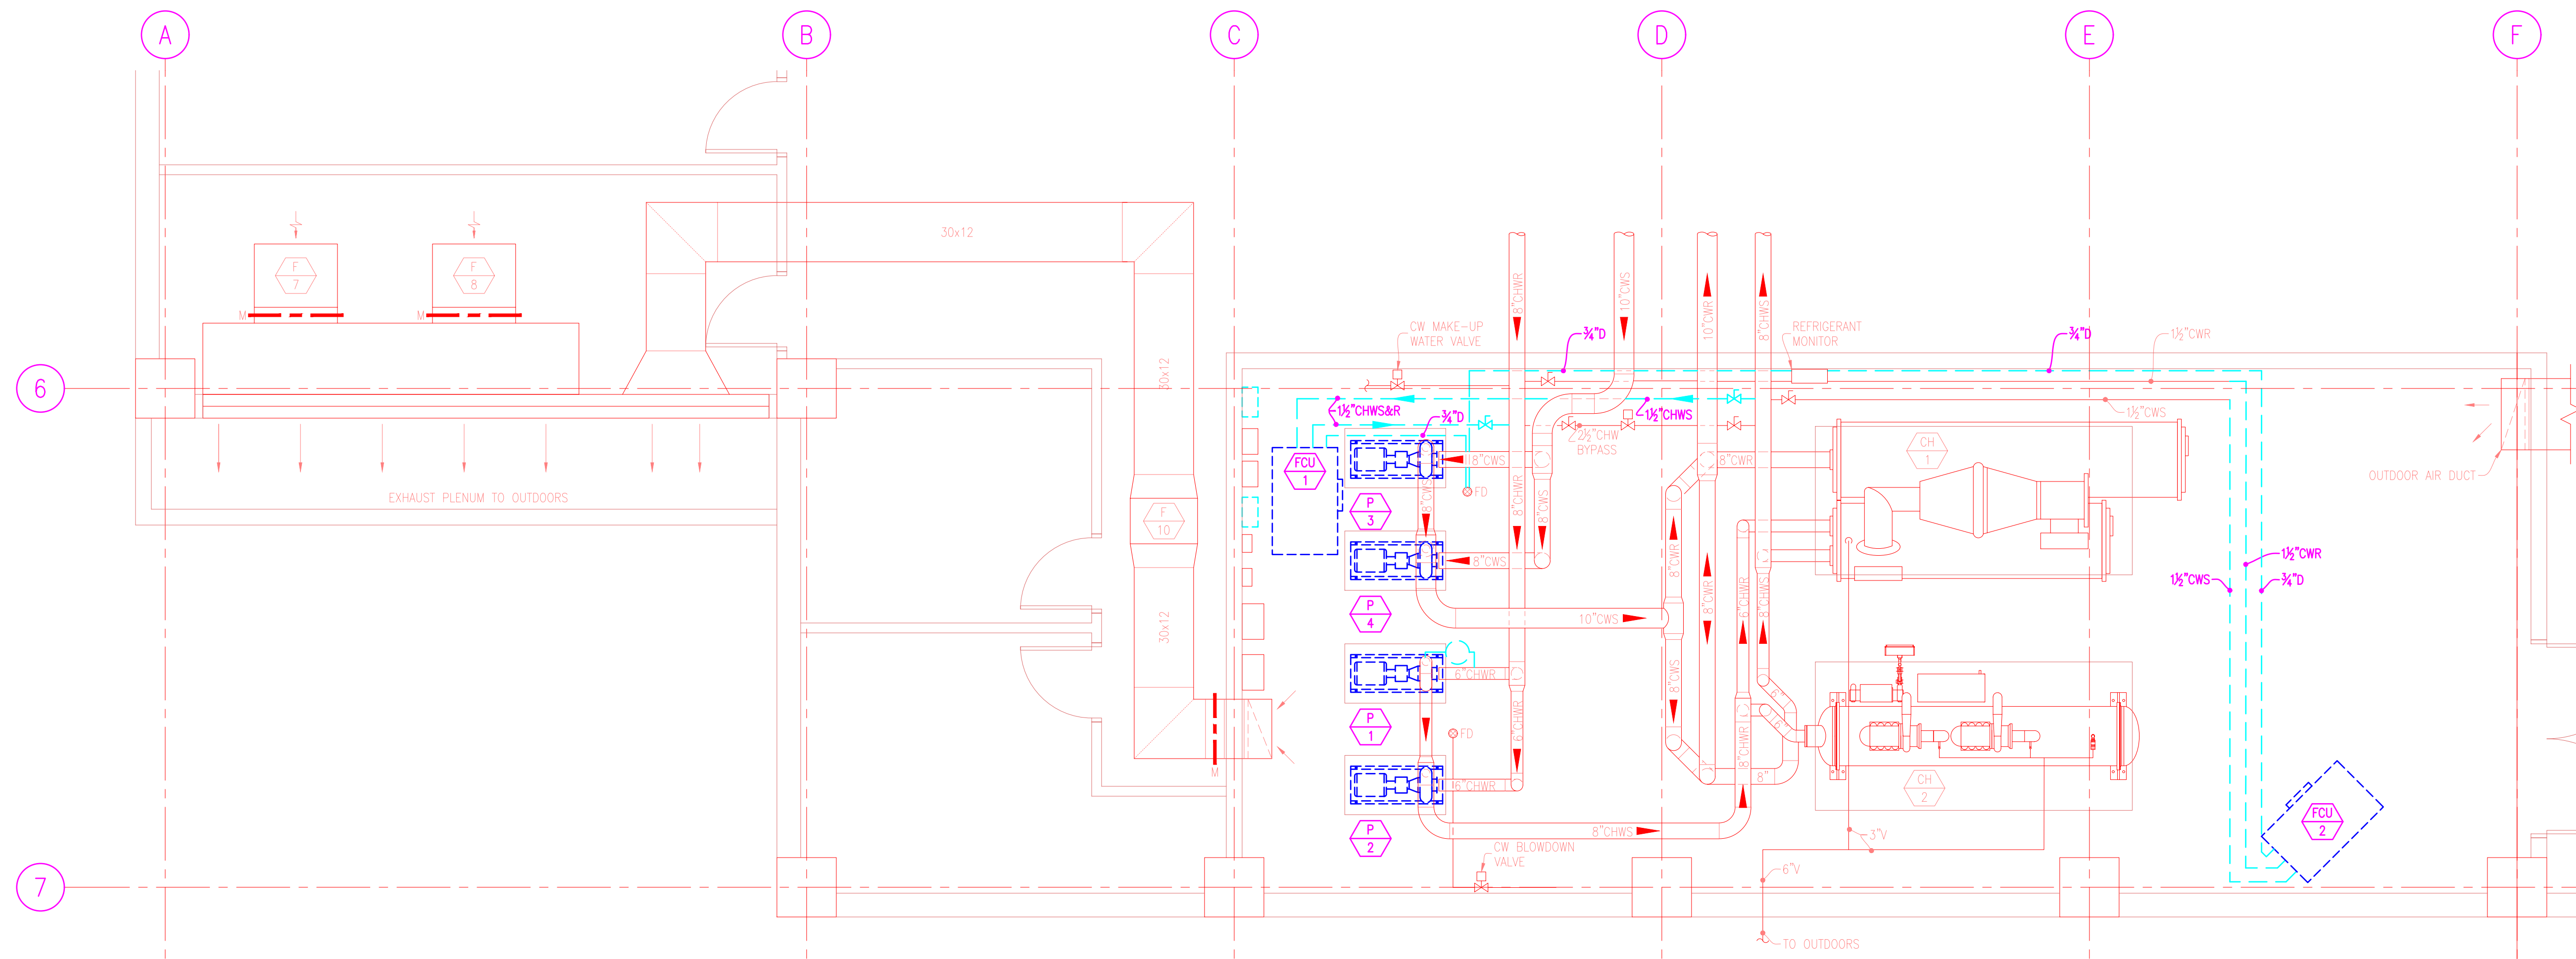

PARTIAL BASEMENT MECHANICAL DEMOLITION PLAN
SCALE: 1/4"=1'-0"

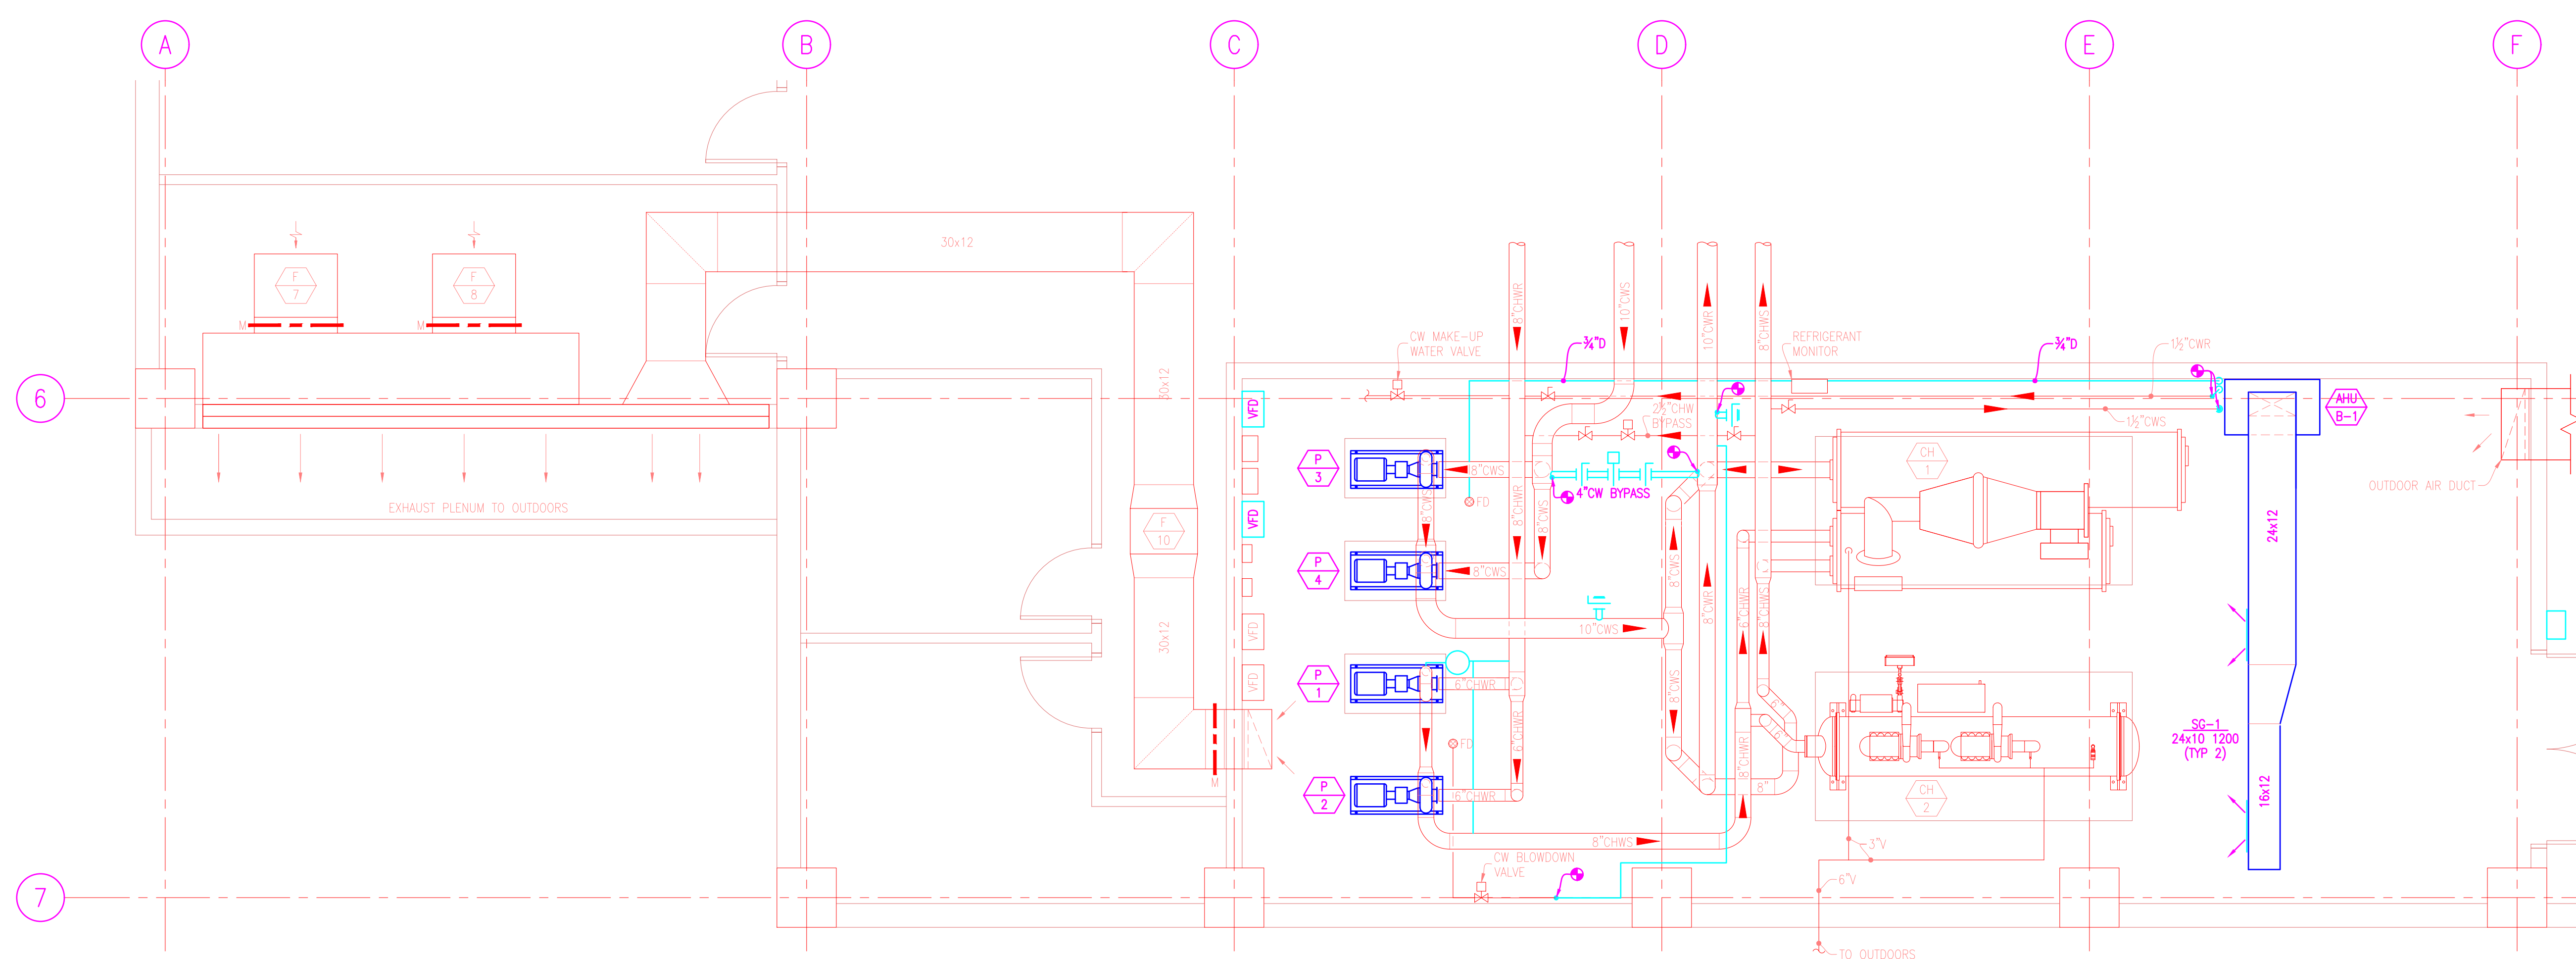

PARTIAL BASEMENT NEW MECHANICAL PLAN
SCALE: 1/4"=1'-0"

DATE:	
REVISION DESCRIPTION:	
ENGINEER'S STAMP	

ANDY'S BEST CAD
1323 CARLYLE PARK CIRCLE
HIGHLANDS RANCH, CO 80129
303-808-3352
WWW.ANDYSBESTCAD.COM

PROJECT: ABC
DRAWN: ABC
DESIGNED:
CLIENT:
DATE: 03/10/22
SCALE: 1/4"=1'-0"

PROJECT: COMMERCIAL OFFICE BUILDING
CHILLER PLANT RENOVATION
MECHANICAL
CONSTRUCTION DRAWINGS

DRAWING TITLE: PARTIAL BASEMENT
MECHANICAL DEMOLITION
& NEW PLANS

DRAWING NO: M01
OF

