




© 2022 ANDY'S BEST CAD. ALL RIGHTS RESERVED. THIS DRAWING IS THE PROPERTY OF ANDY'S BEST CAD AND IS PROTECTED BY COPYRIGHT LAWS OF THE UNITED STATES OF AMERICA. ANY UNAUTHORIZED USE OF THE INFORMATION CONTAINED HEREIN OR PART THEREOF IS STRICTLY PROHIBITED. RECEIPT OR POSSESSION THEREOF DOES NOT CONVEY OR TRANSFER ANY RIGHT TO MAKE, COPY, MANUFACTURE AND/OR SELL EITHER THE DRAWING OR THE ITEMS SHOWN THEREON.

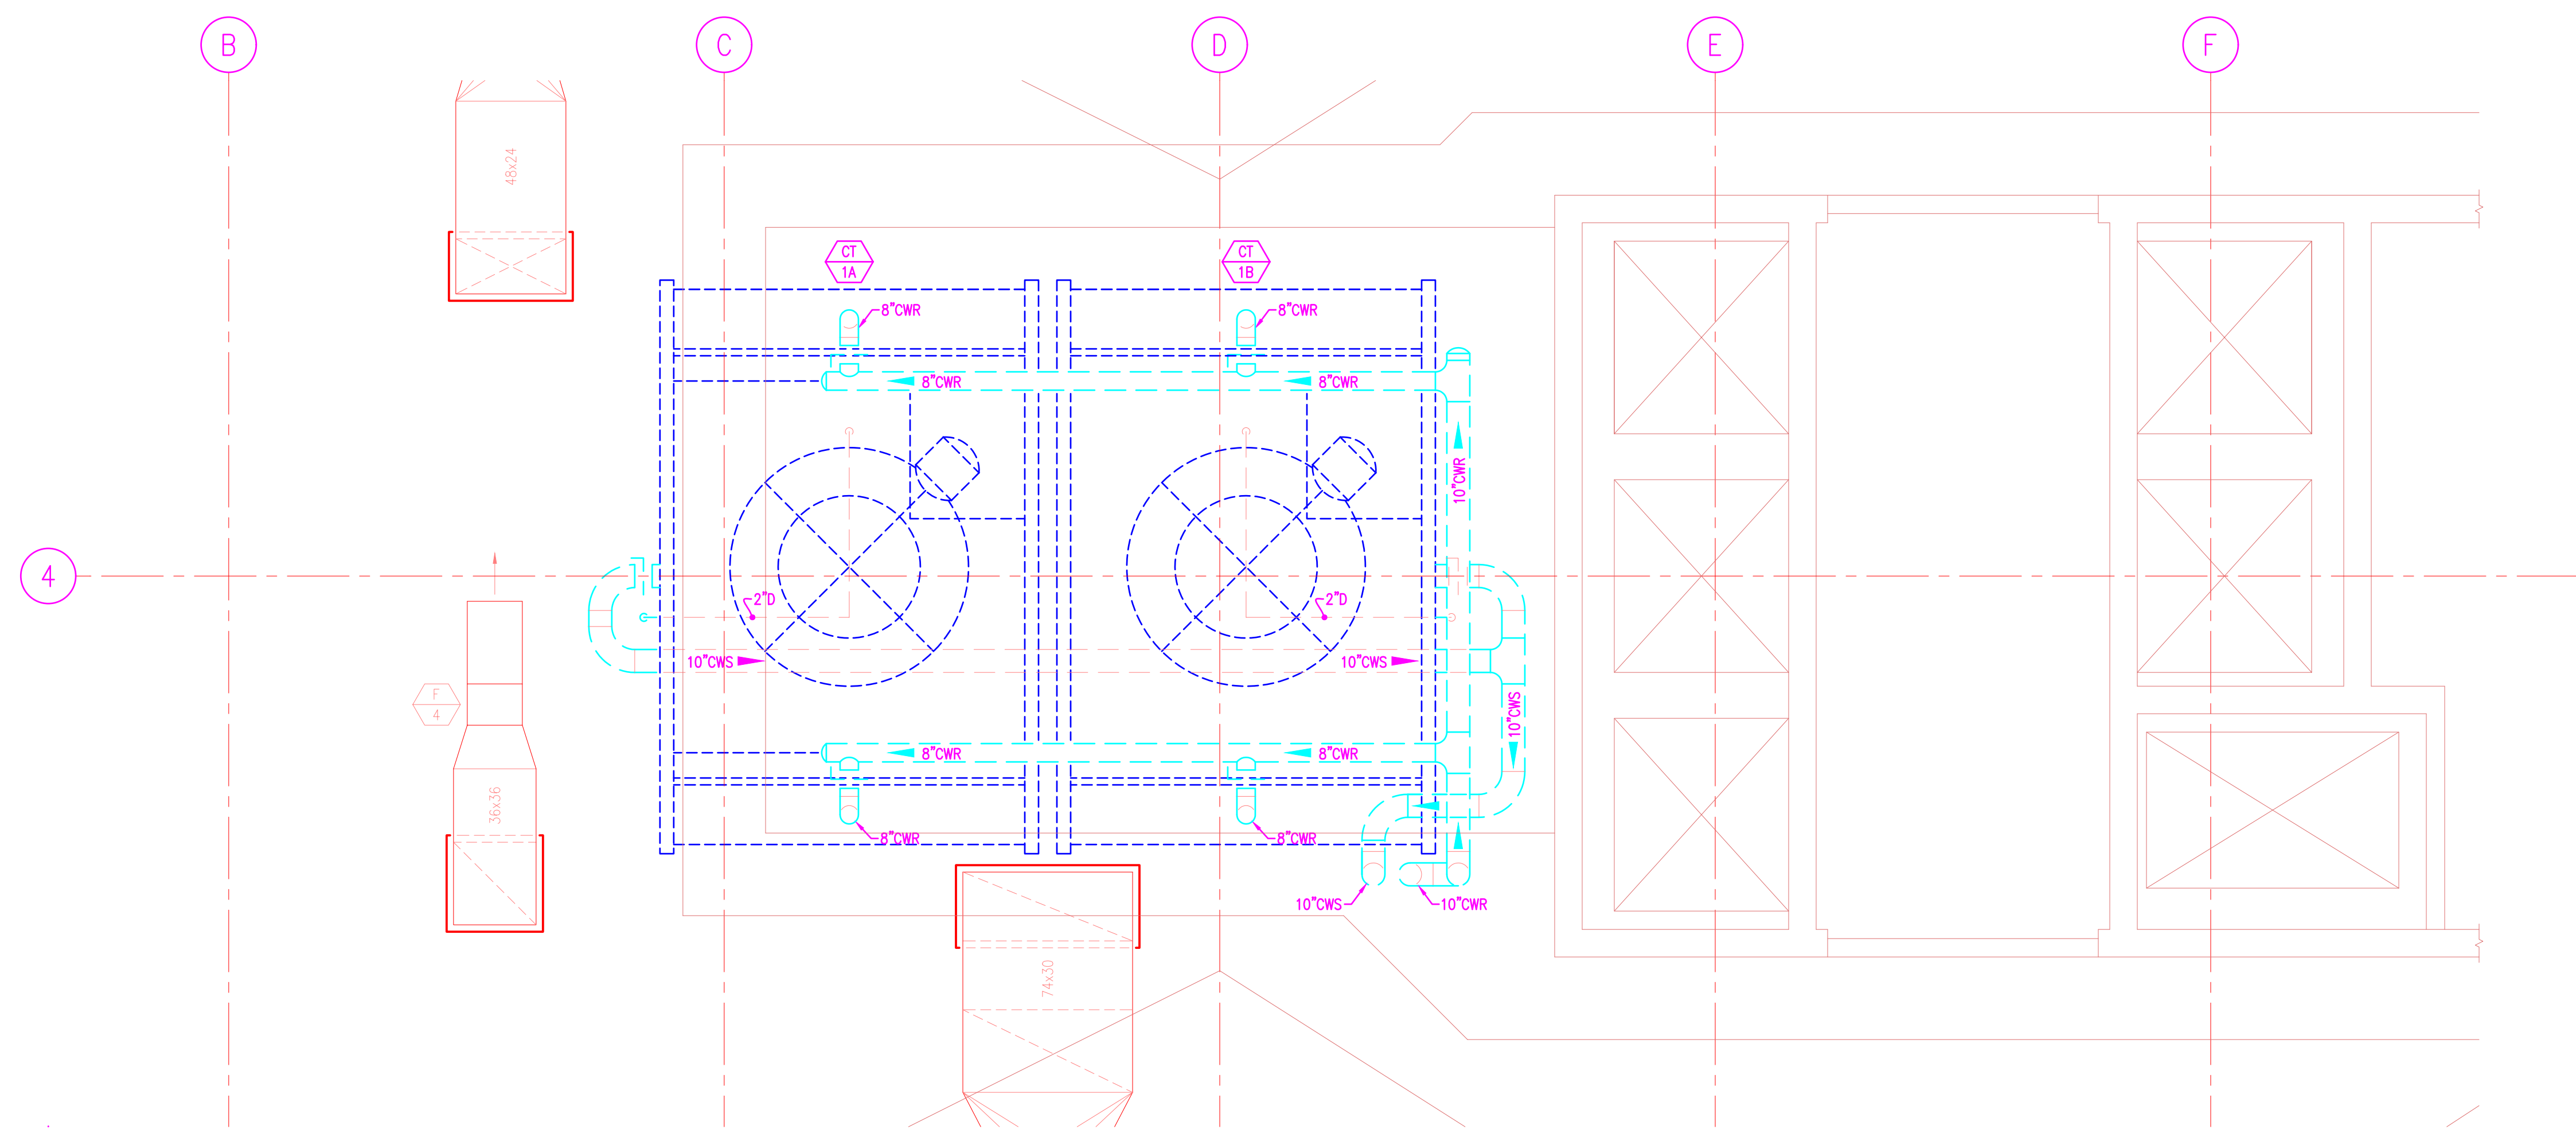

PARTIAL ROOF MECHANICAL DEMOLITION PLAN
SCALE: 1/4"=1'-0"

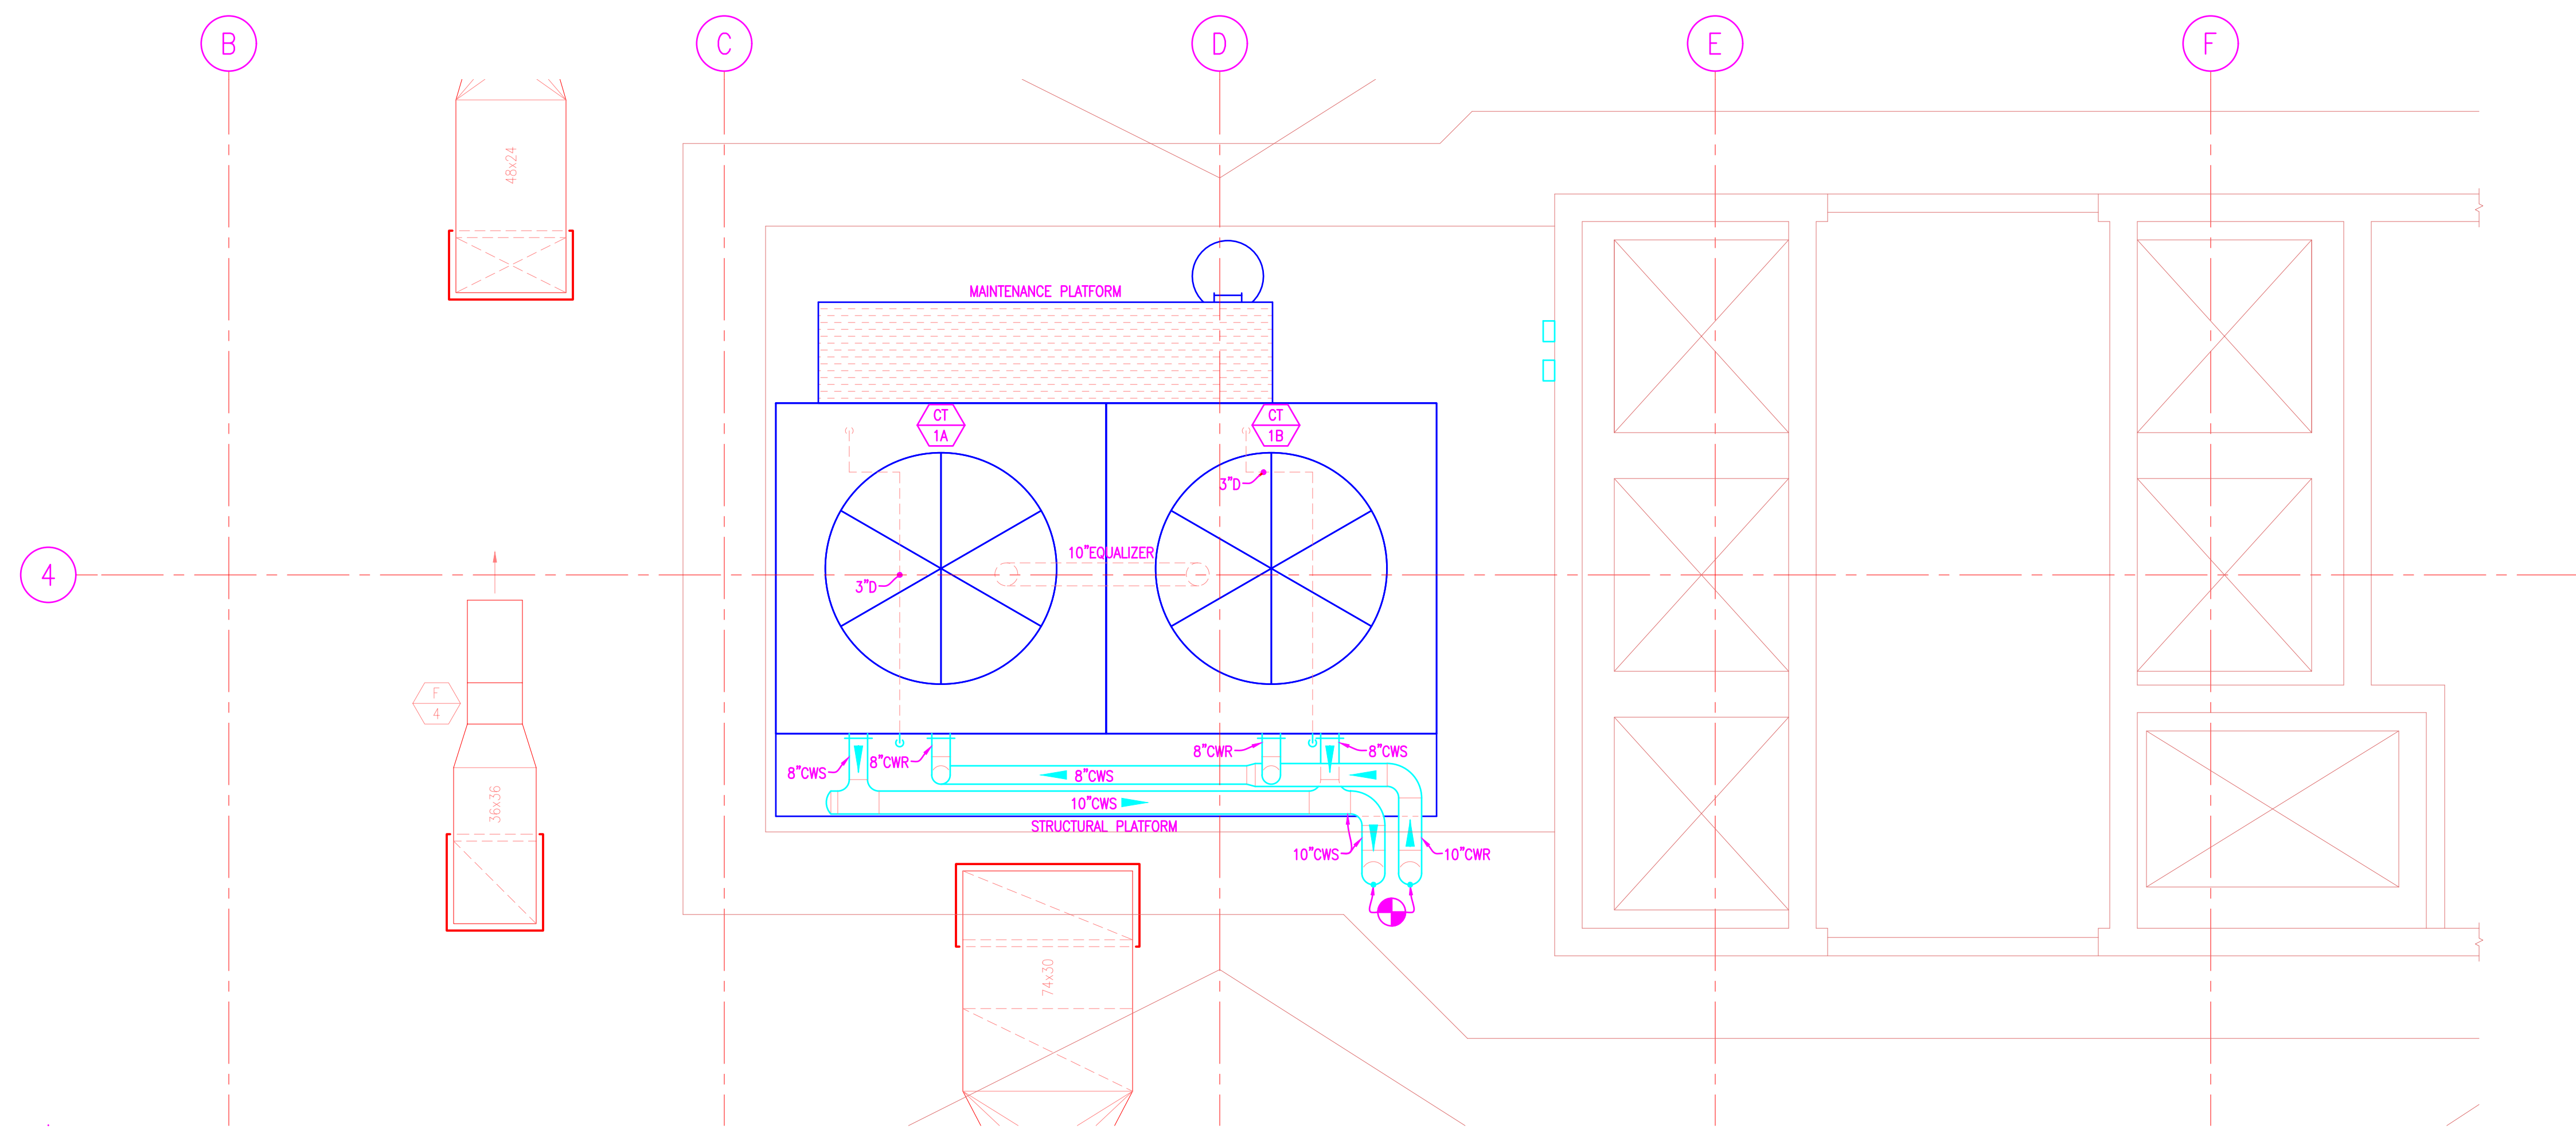

PARTIAL ROOF NEW MECHANICAL PLAN
SCALE: 1/4"=1'-0"

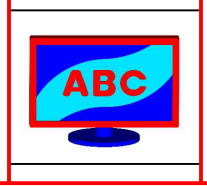

DRAWING NO:
M02
OF

DRAWING TITLE:
**PARTIAL ROOF
MECHANICAL DEMOLITION
& NEW PLANS**

PROJECT:
**COMMERCIAL OFFICE BUILDING
CHILLER PLANT RENOVATION
MECHANICAL
CONSTRUCTION DRAWINGS**

DRAWN: **ABC**
DESIGNED:
CLIENT:
DATE: **03/10/22**
SCALE: **1/4"=1'-0"**

ANDY'S BEST CAD
1323 CARLYLE PARK CIRCLE
HIGHLANDS RANCH, CO 80129
303-808-3352
WWW.ANDYSBESTCAD.COM

ENGINEER'S STAMP

REVISION DESCRIPTION:

DATE: