

©2022 ANDY'S BEST CAD. ALL RIGHTS RESERVED. THIS DRAWING IS THE PROPERTY OF ANDY'S BEST CAD AND IS PROTECTED BY COPYRIGHT LAWS OF THE UNITED STATES OF AMERICA. ANY UNAUTHORIZED USE OF THE INFORMATION CONTAINED HEREIN OR PART THEREOF IS STRICTLY PROHIBITED. REPEAT OR POSSESSION THEREOF DOES NOT CONVEY OR TRANSFER ANY RIGHT TO MAKE, COPY, MANUFACTURE AND/OR SELL EITHER THE DRAWING OR THE ITEMS SHOWN THEREIN.

DATE:	
REV:	
REVISION DESCRIPTION:	
ENGINEER'S STAMP:	

ANDY'S BEST CAD
1323 CARLYLE PARK CIRCLE
HIGHLANDS RANCH, CO 80129
303-808-3352
WWW.ANDYSBESTCAD.COM

DRAWN: ABC
DESIGNED:
CLIENT: 03/12/22
DATE: AS SHOWN
SCALE:


ELEMENTARY SCHOOL
BOILER ROOM
MECHANICAL
CONSTRUCTION DRAWINGS

PROJECT:


BOILER ROOM
MECHANICAL PLAN
SCHEMATIC DIAGRAMS

DRAWING TITLE:


DRAWING NO:
M02
OF

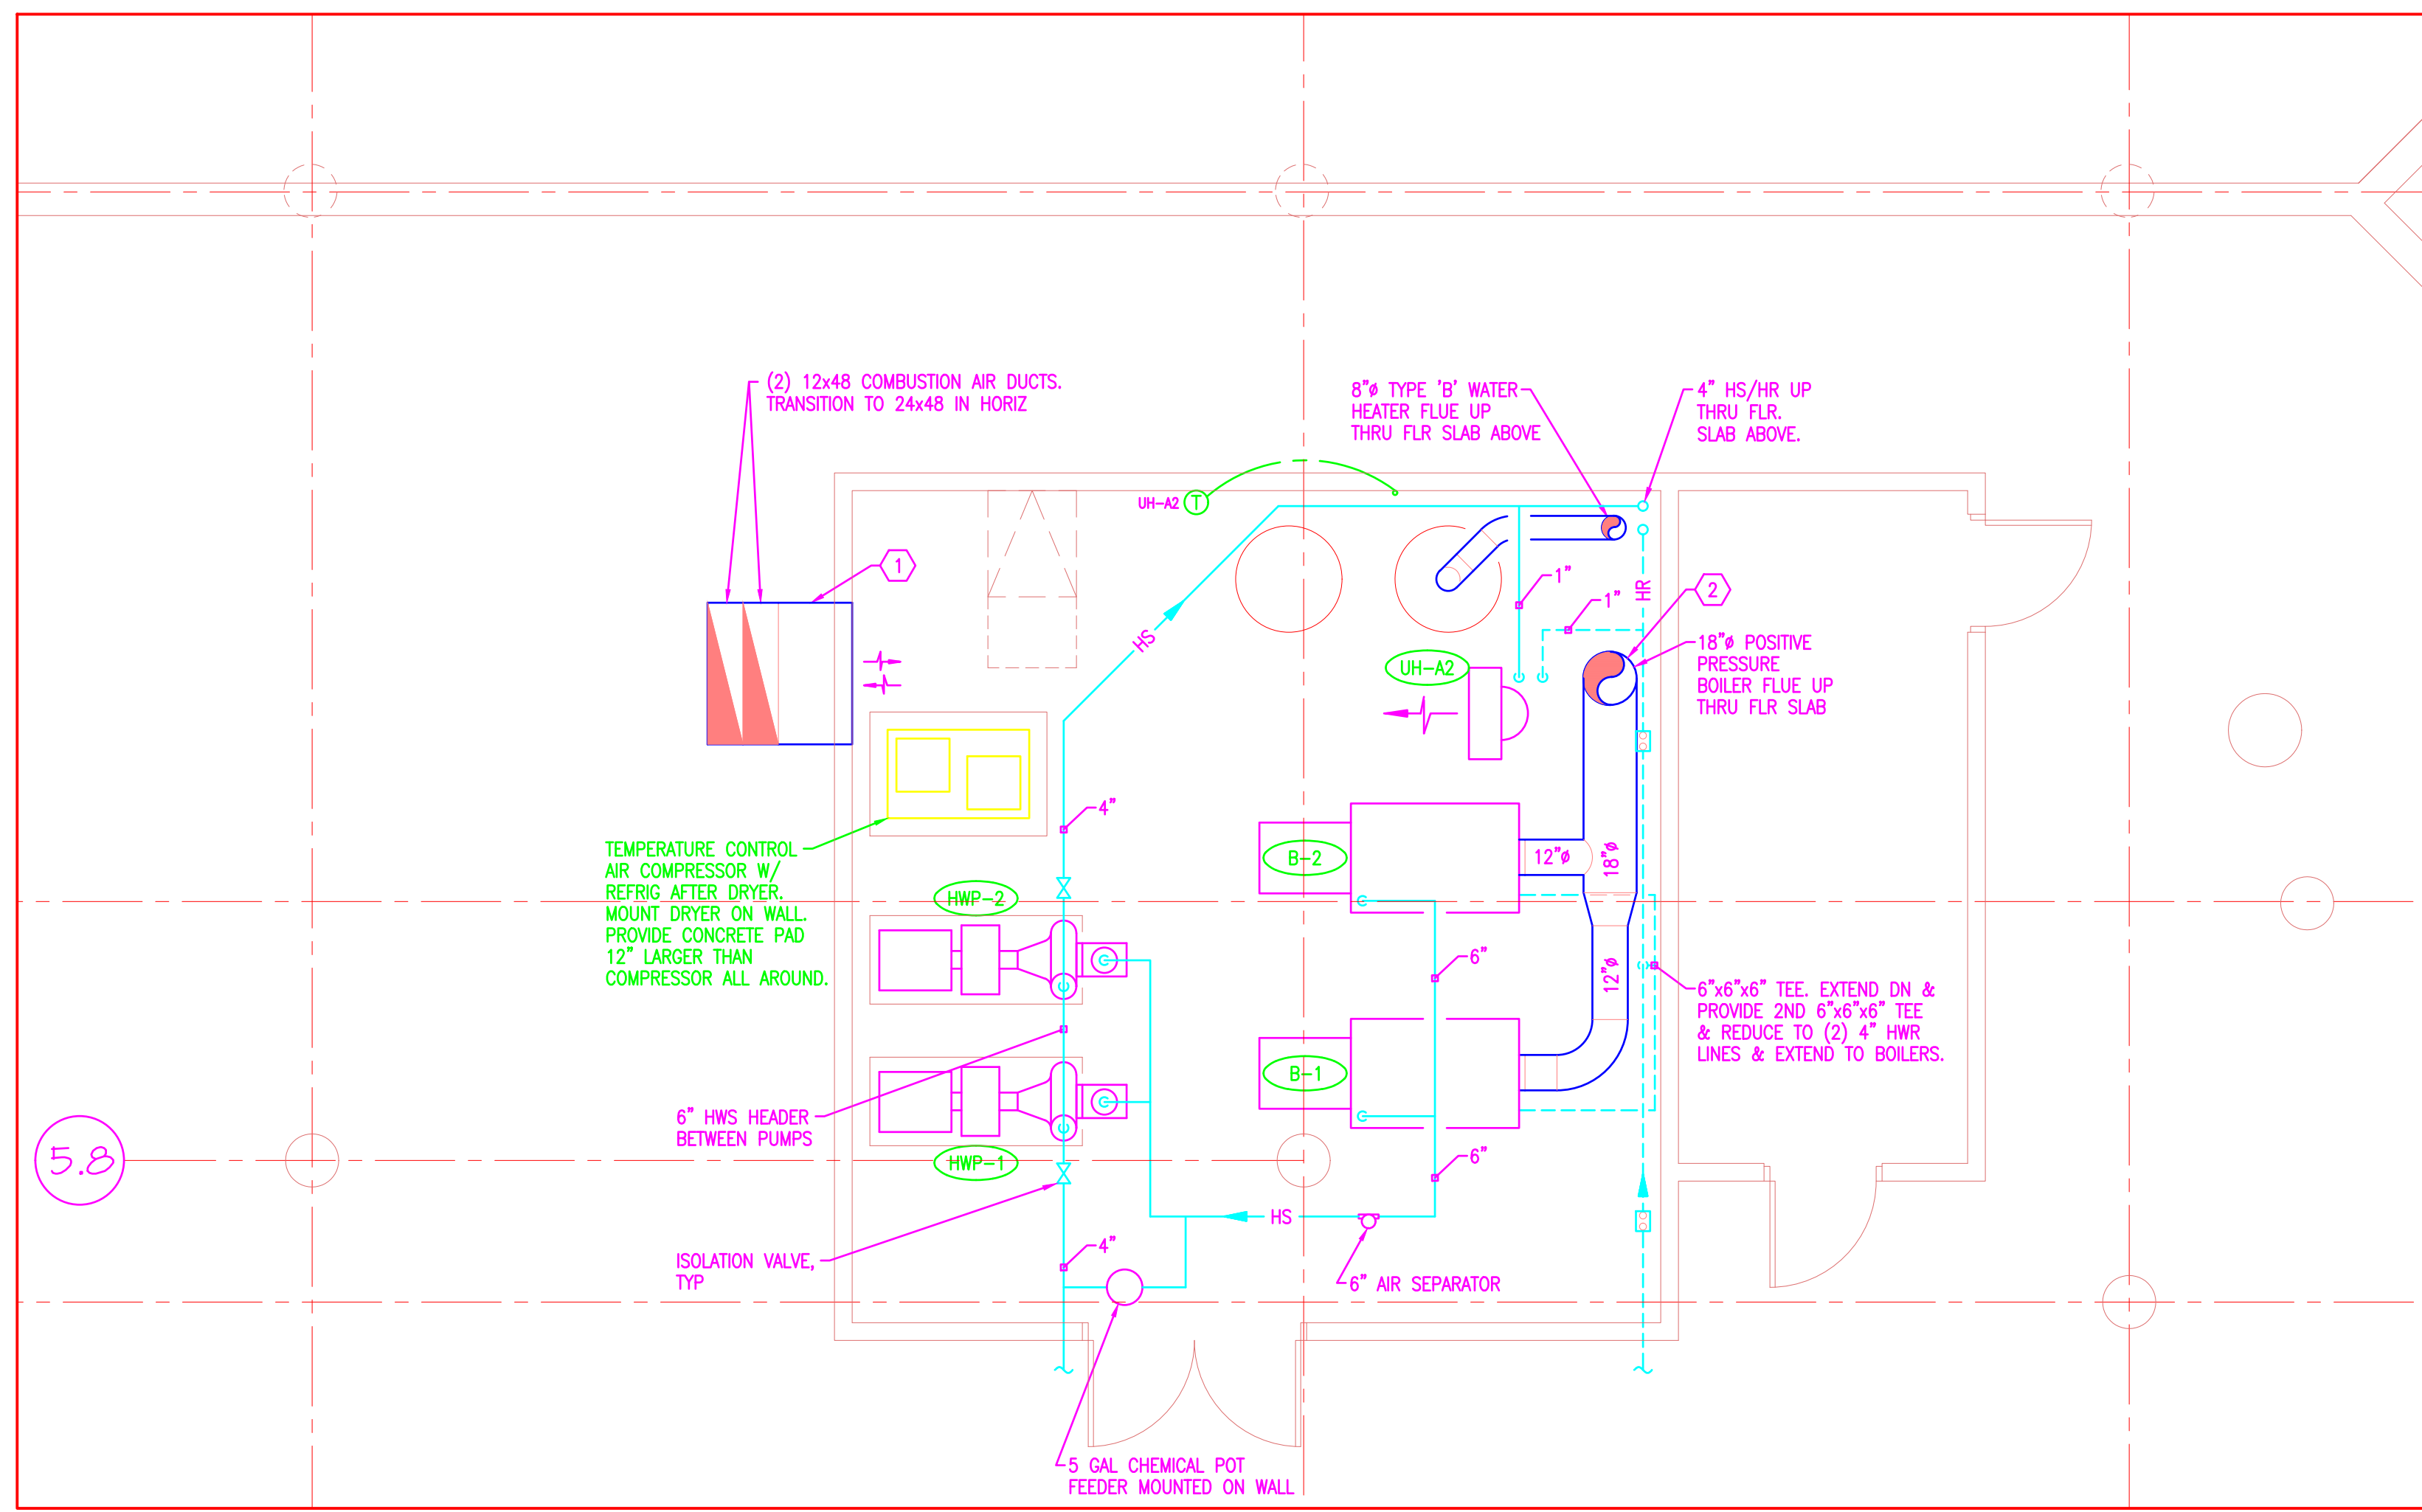


BOILER ROOM MECHANICAL PLAN
SCALE: 1/4"=1'-0"

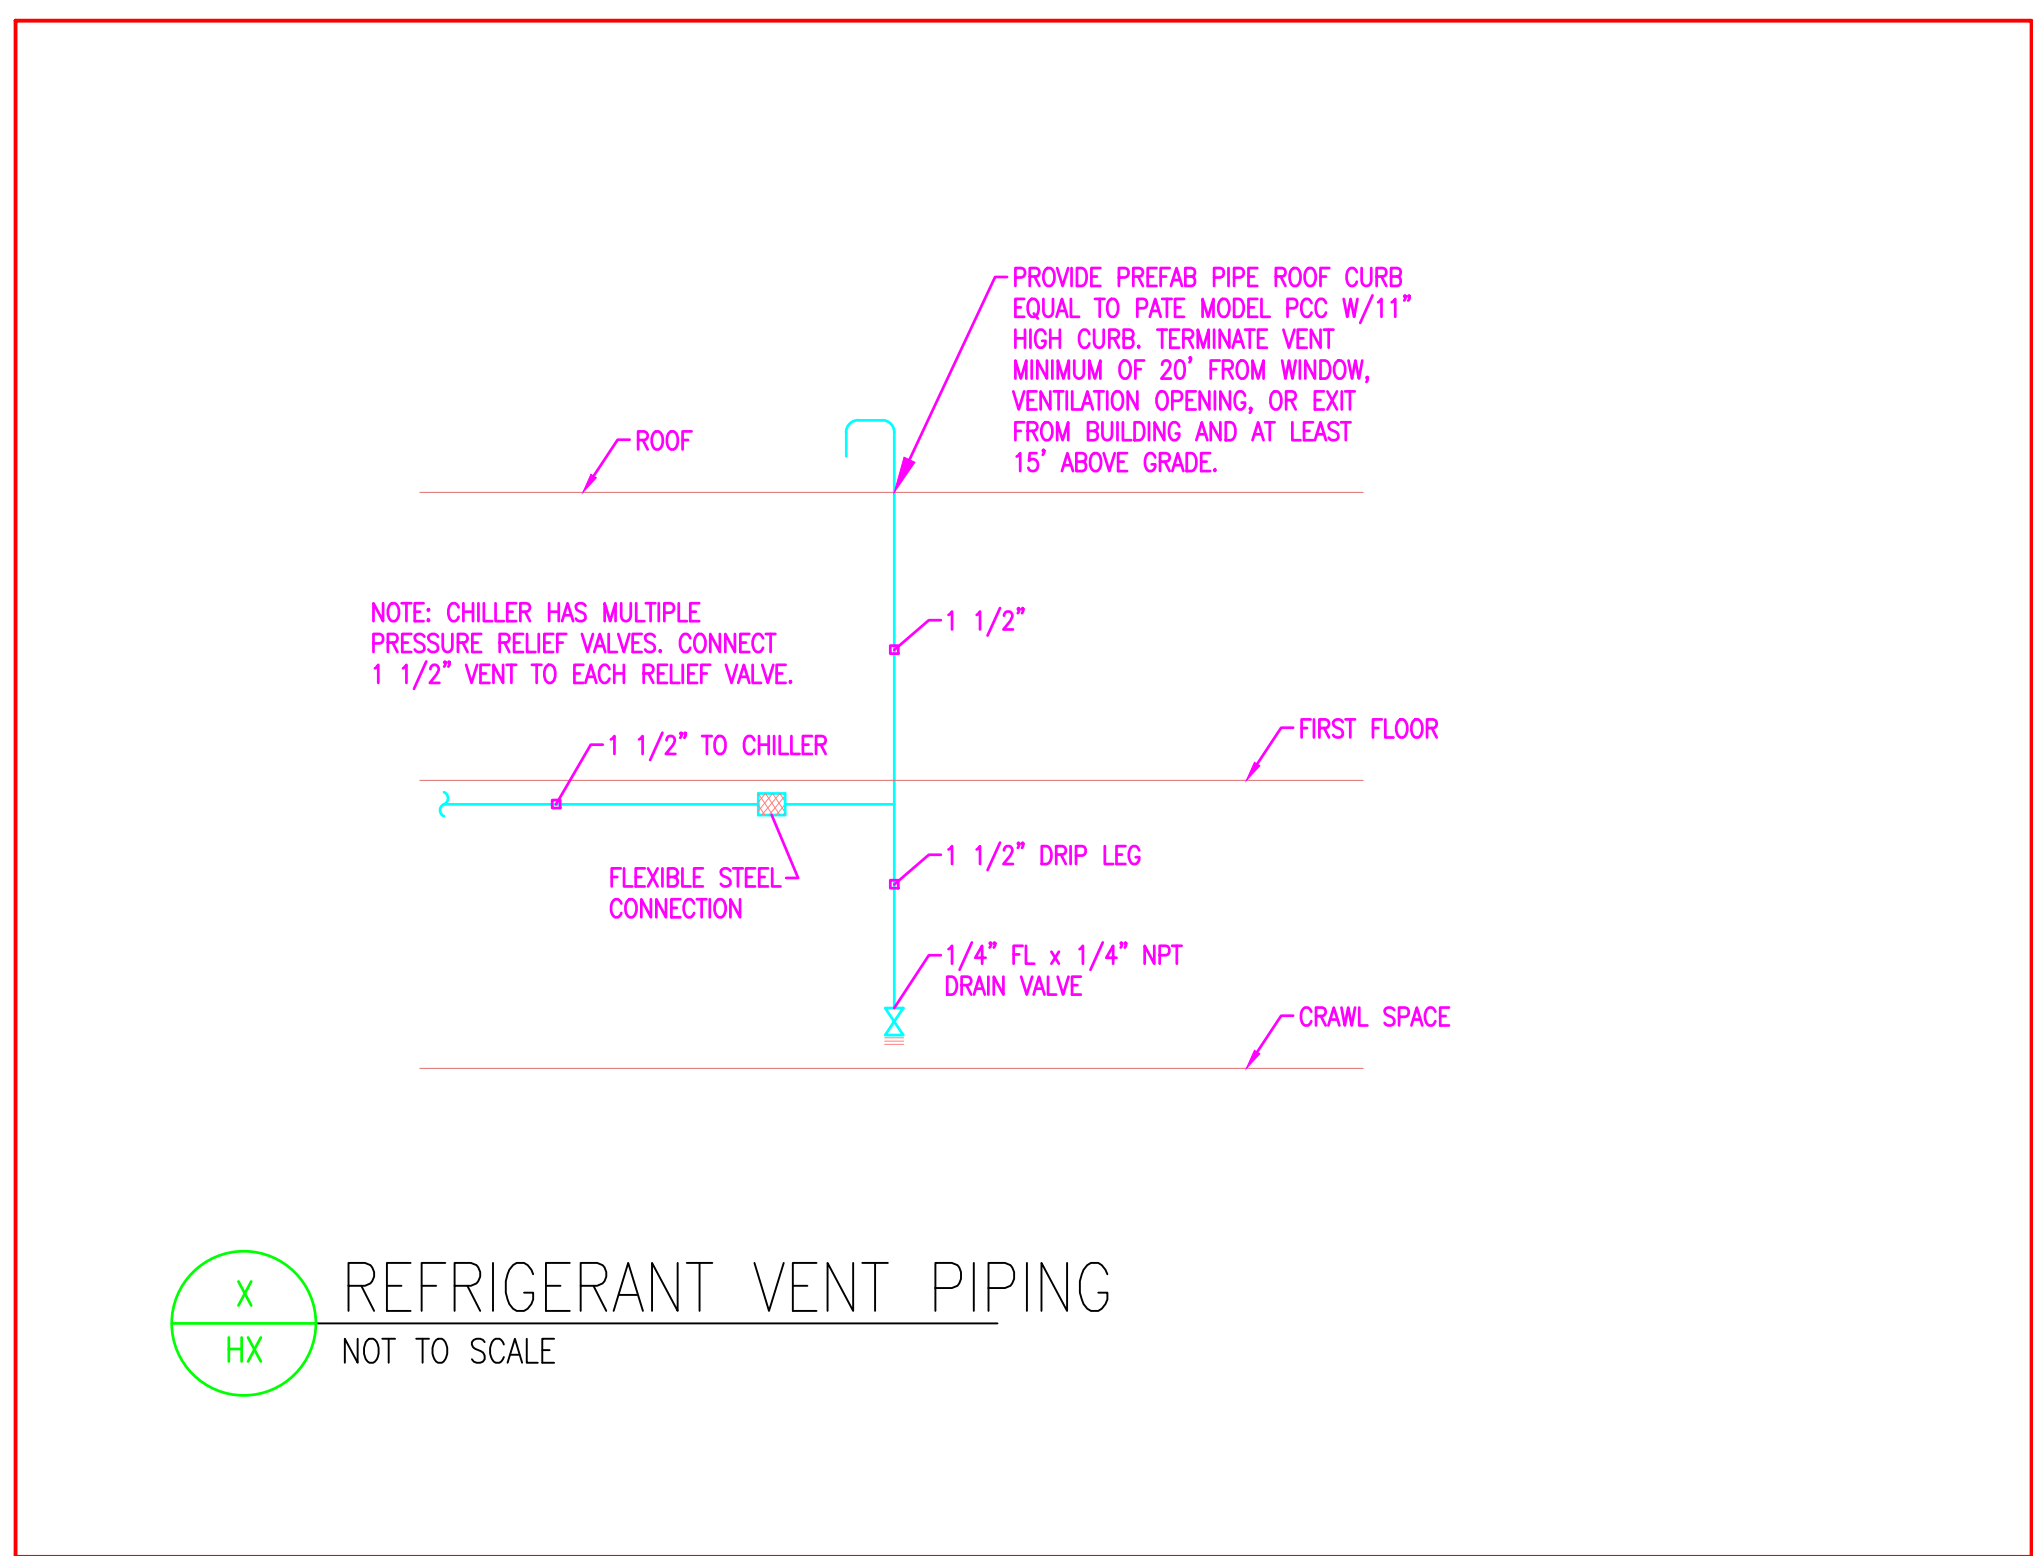

REFRIGERANT VENT PIPING
NOT TO SCALE

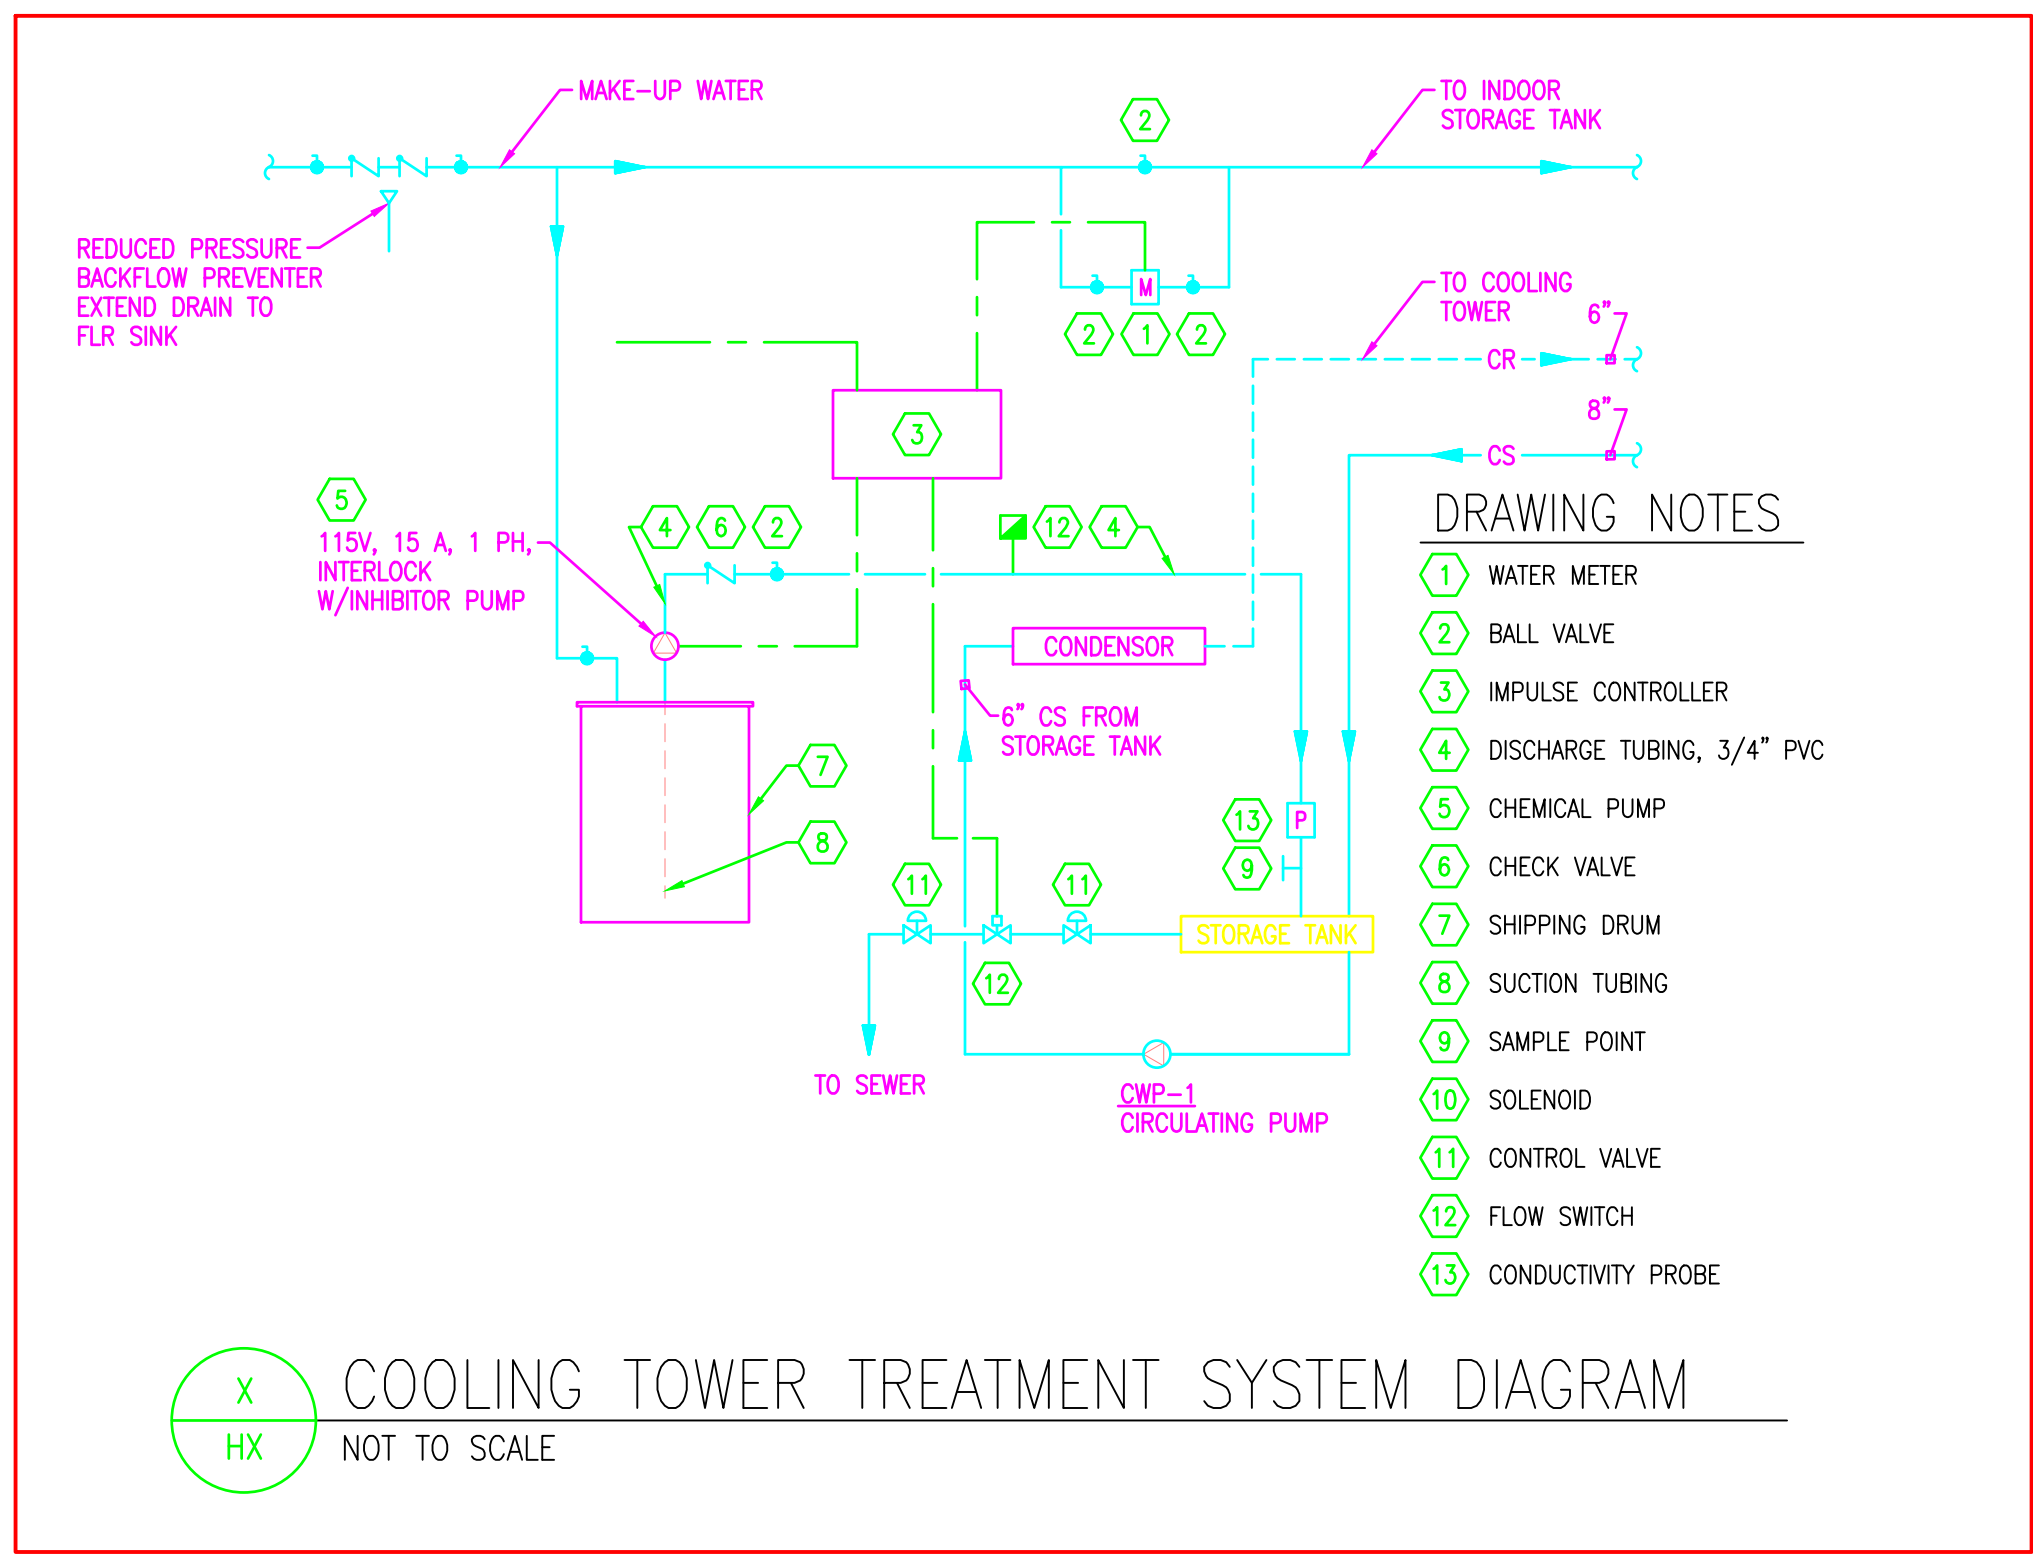

COOLING TOWER TREATMENT SYSTEM DIAGRAM
NOT TO SCALE

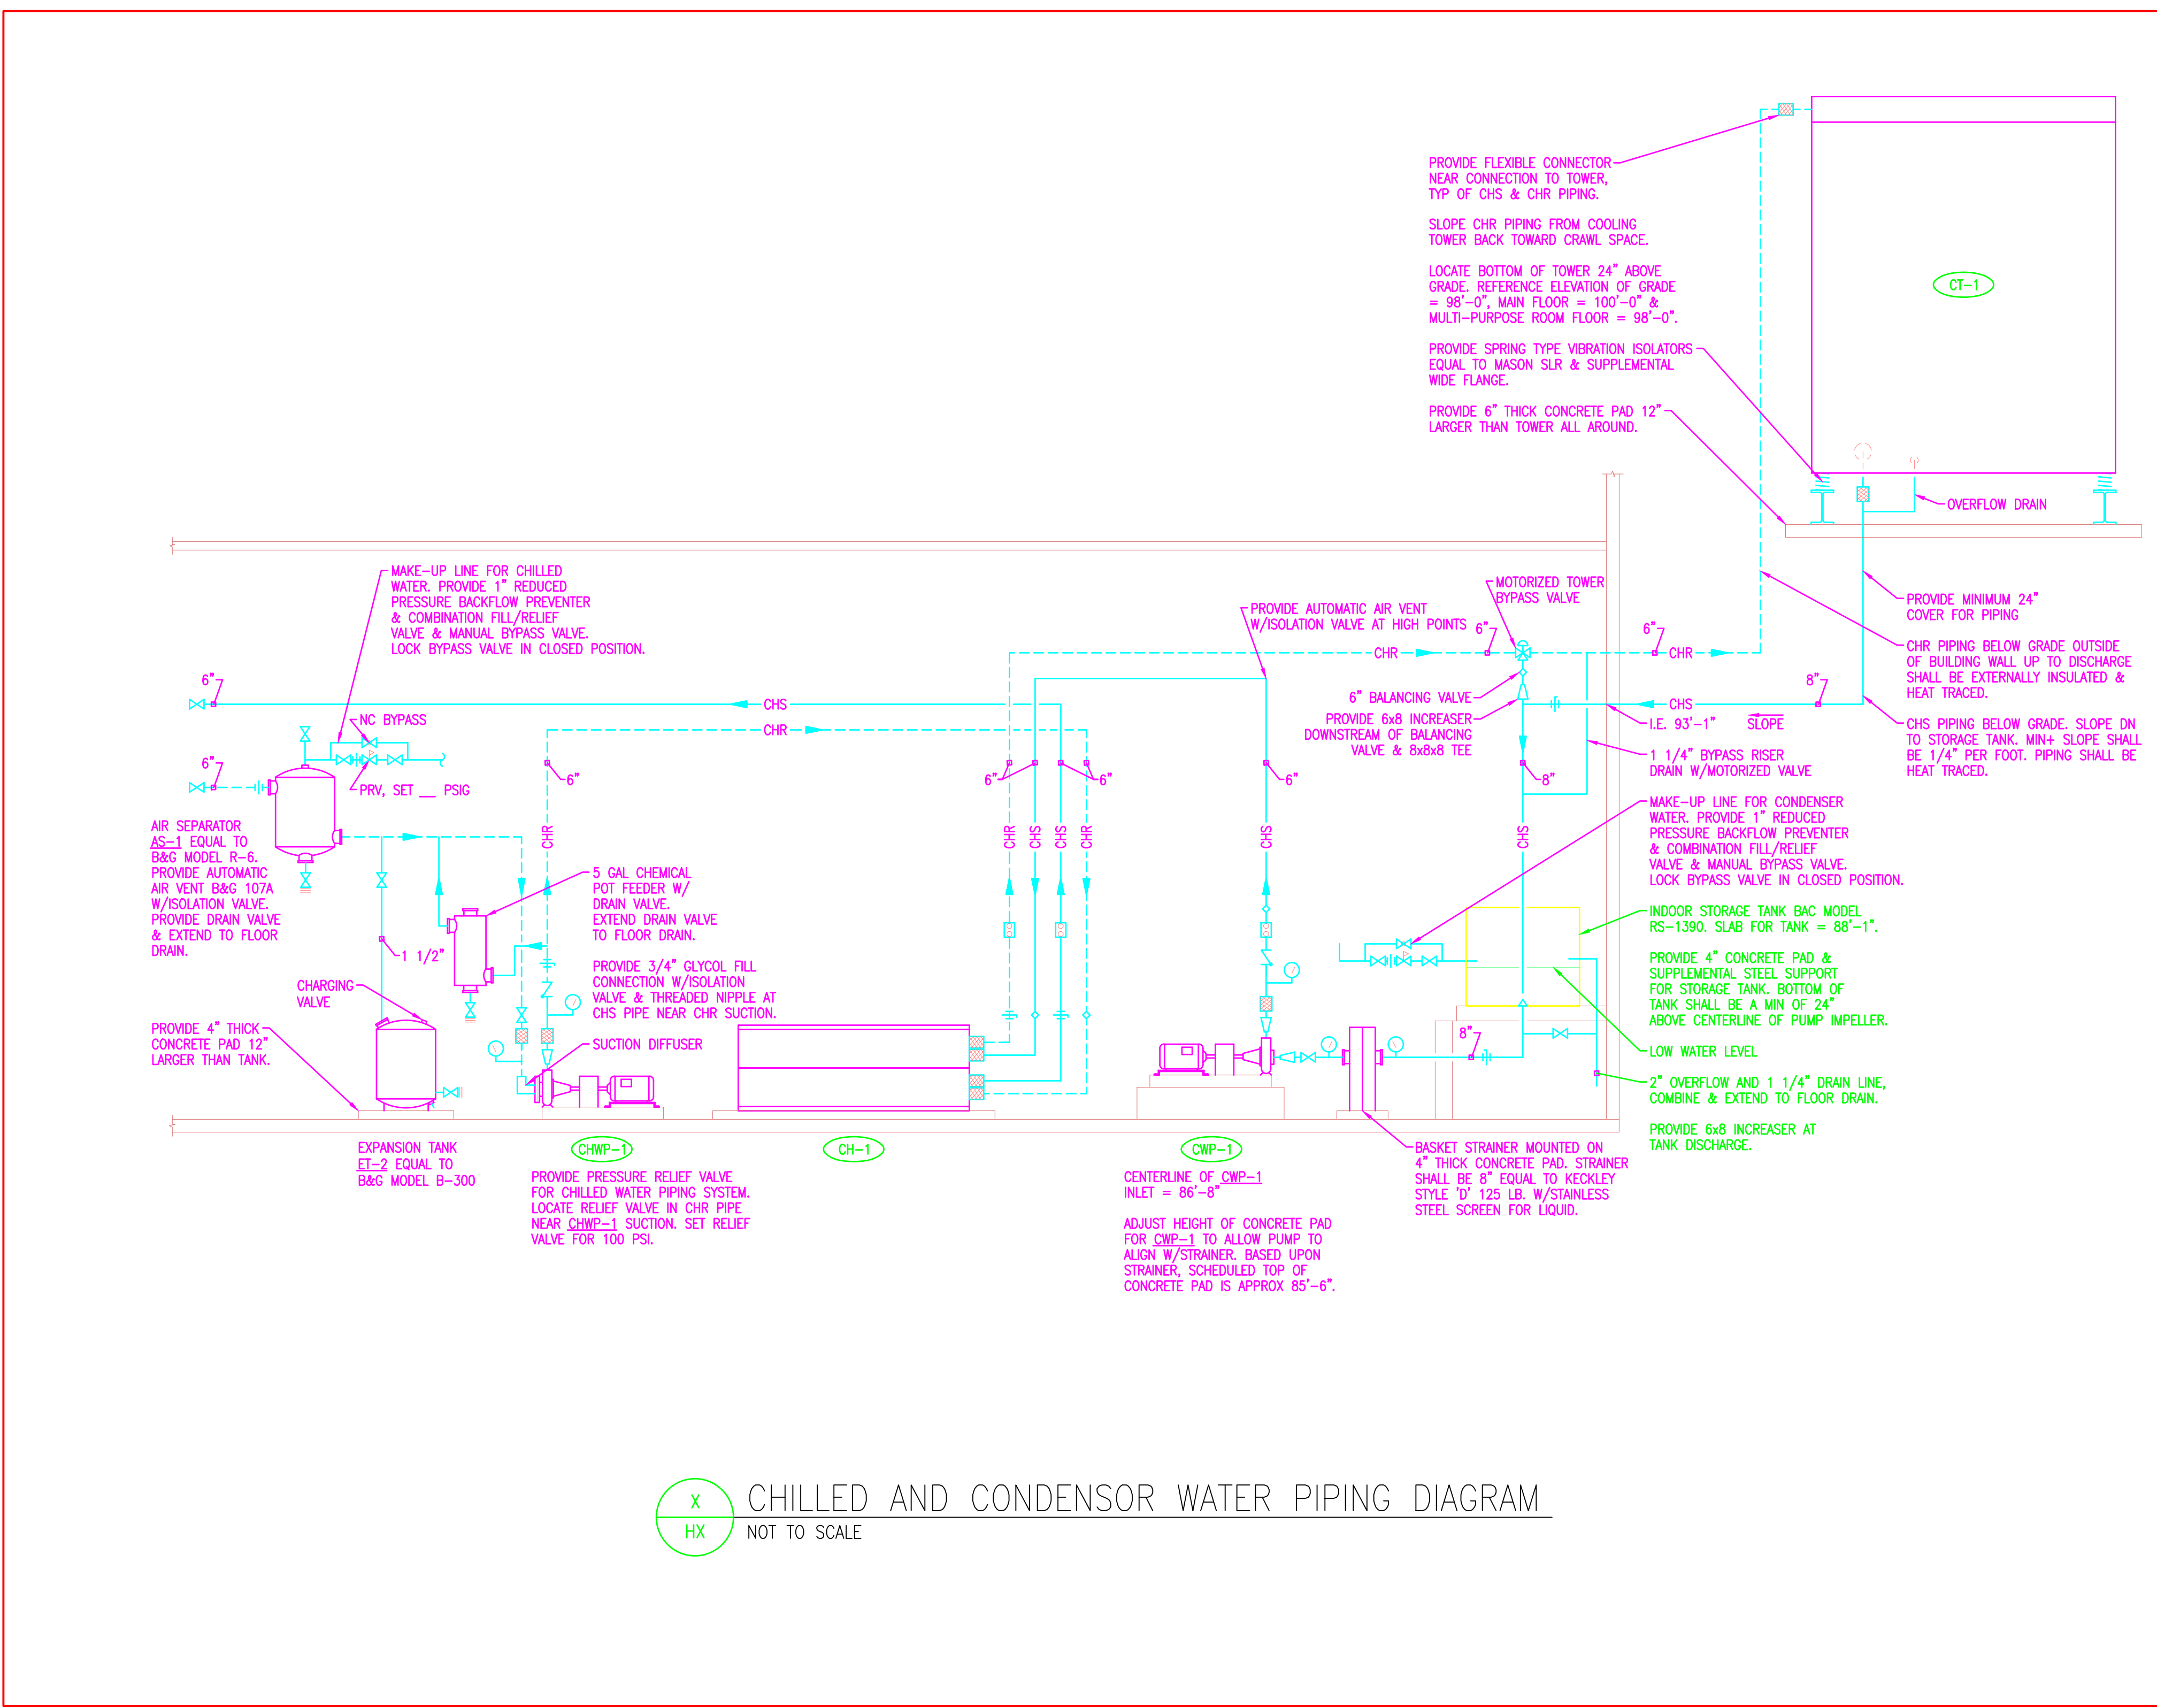

CHILLED AND CONDENSOR WATER PIPING DIAGRAM
NOT TO SCALE