









COMMUNICATION PLAN LEGEND

-  BUILDING STANDARD COMBINATION TELEPHONE/DATA LINE DUPLEX OUTLET
-  AP ACCESS POINT
-  IDFT-XXX CABLE ID
-  REDUNDANT BACKBONE
-  2" J-HOOKS
-  2" J-HOOKS x 2



SECOND FLOOR COMMUNICATION PLAN
SCALE: 1/8"=1'-0"

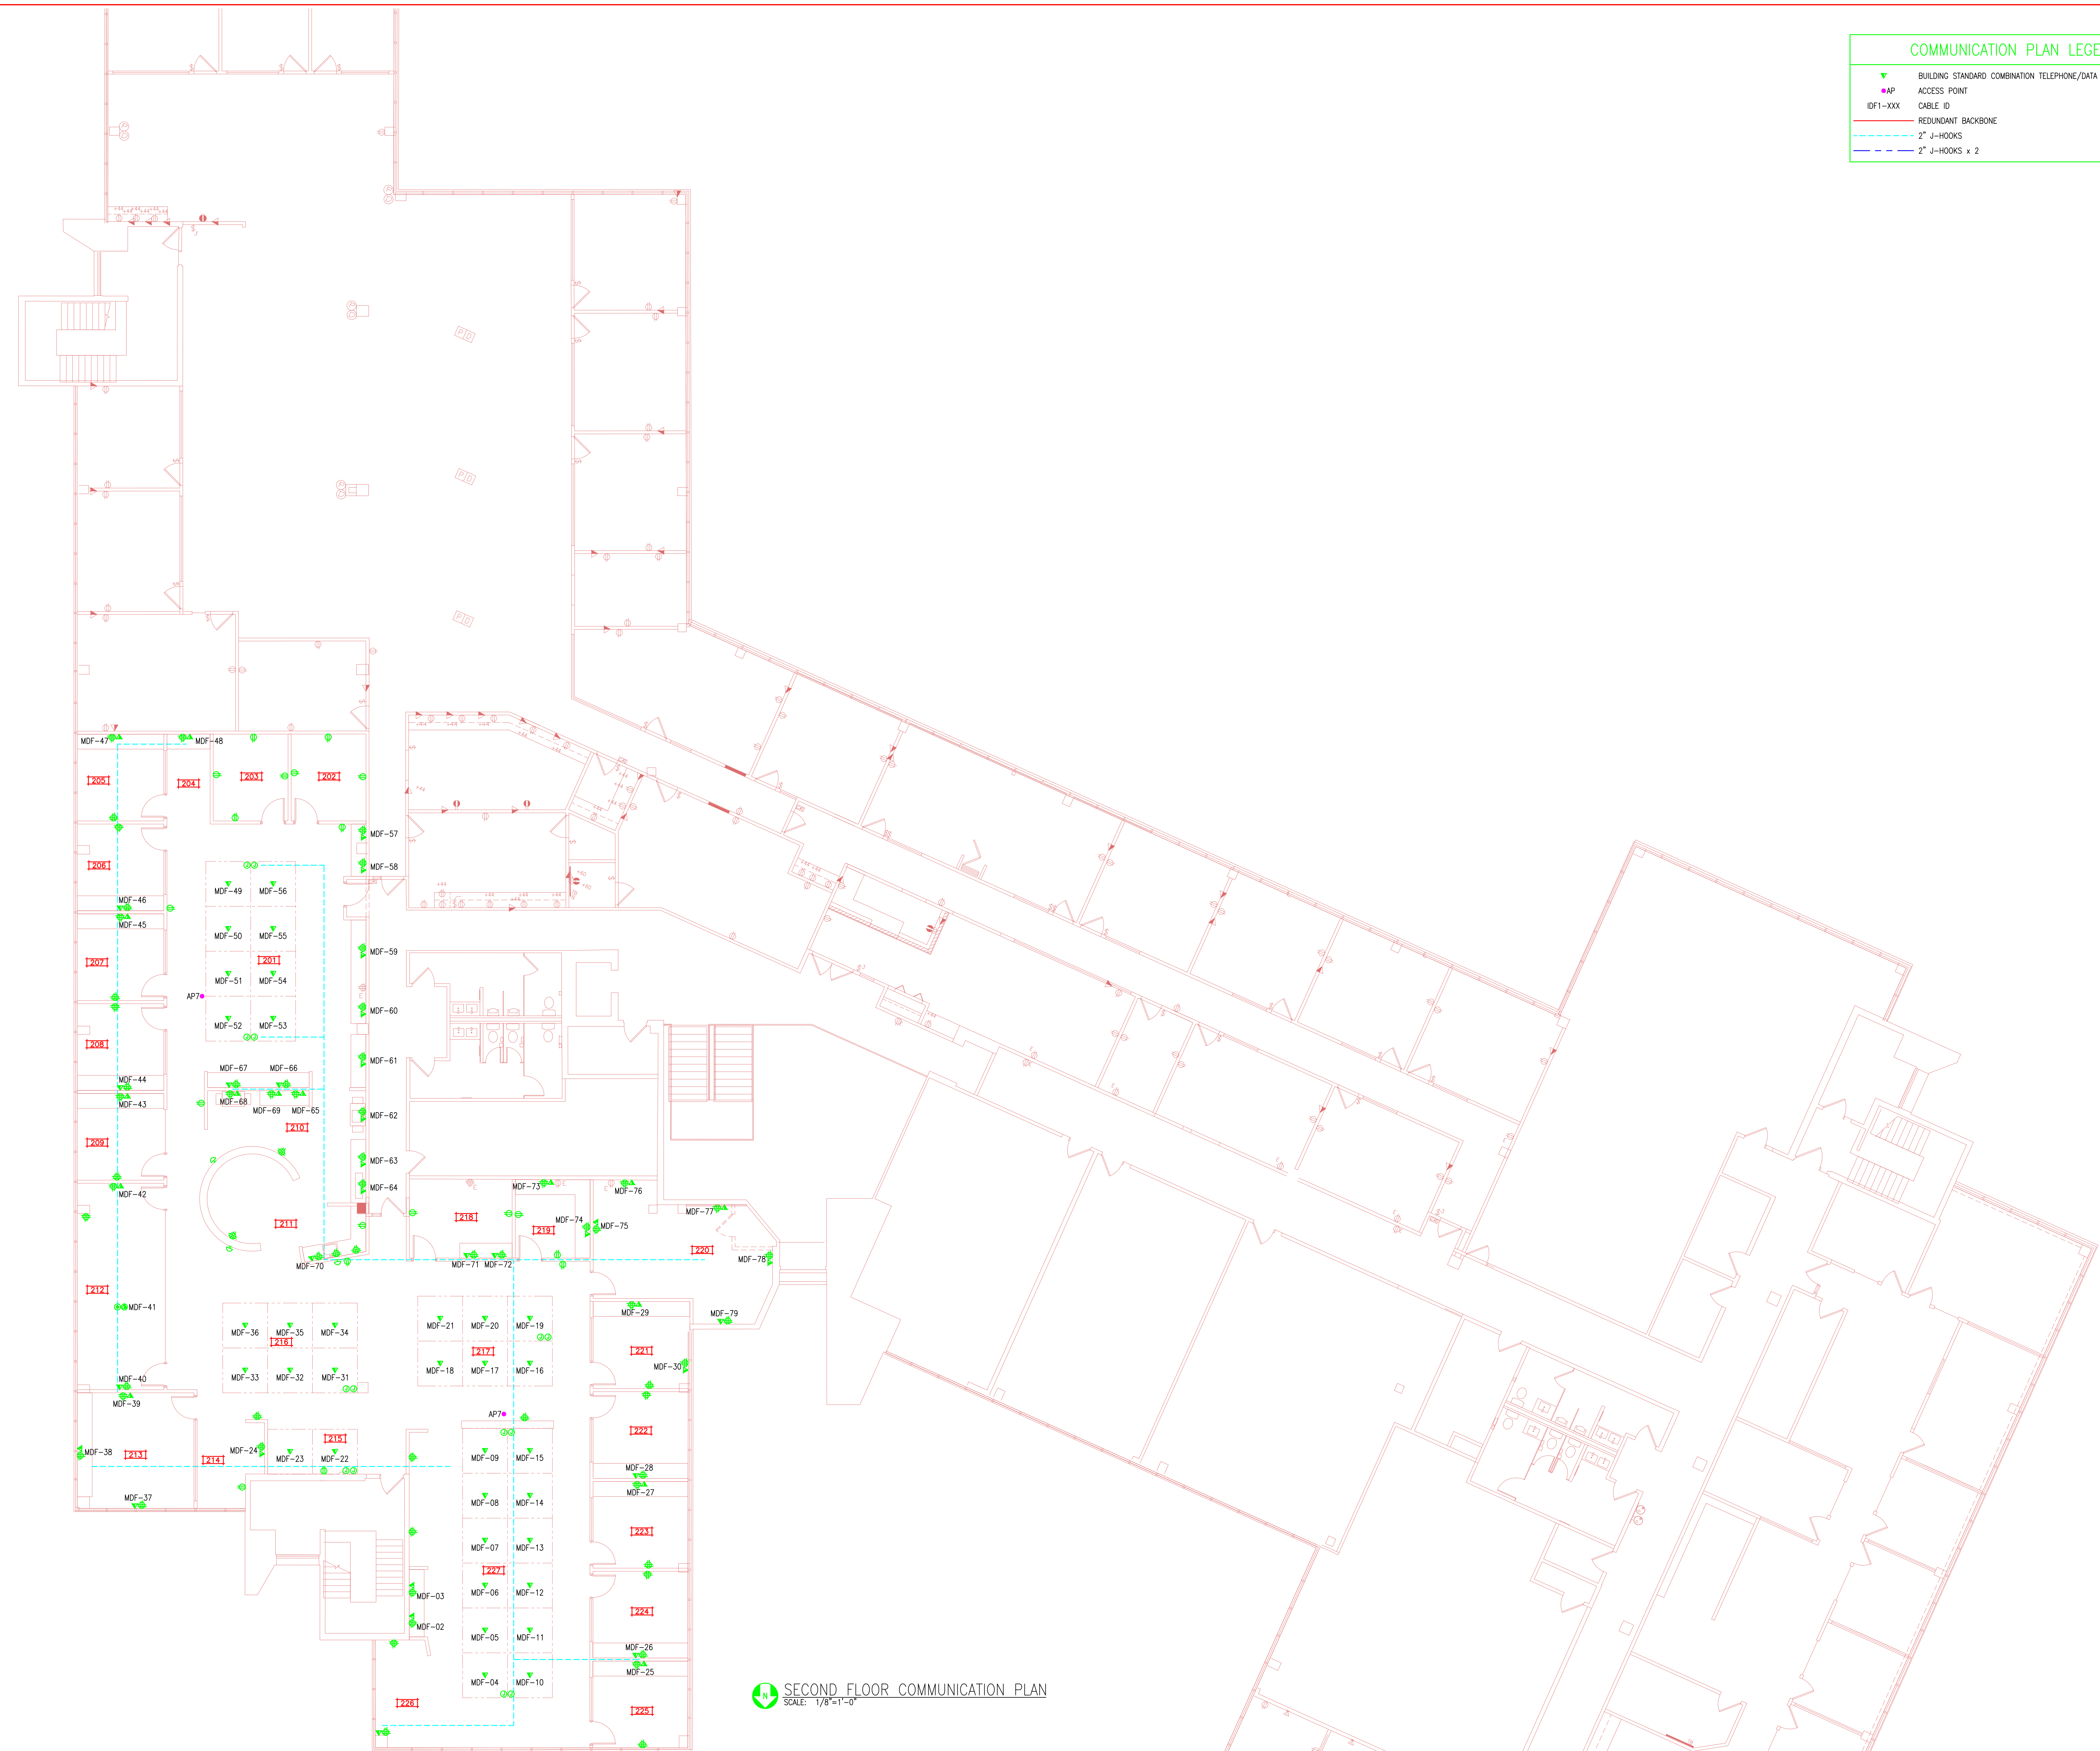DATE:	
REVISION DESCRIPTION:	

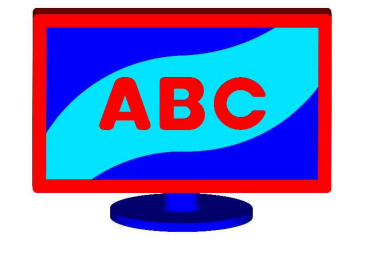

ANDY'S BEST CAD
1323 CARLYLE PARK CIRCLE
HIGHLANDS RANCH, CO 80129
303-808-3352
WWW.ANDYSBESTCAD.COM

DRAWN: ABC
DESIGNED:
CLIENT: 03/20/22
DATE: 1/8"=1'-0"
SCALE:

PROJECT: COMMERCIAL OFFICE BUILDING
COMMUNICATION SYSTEM
CONSTRUCTION DRAWINGS

DRAWING TITLE: SECOND FLOOR COMMUNICATION PLAN

DRAWING NO.: T102
OF

©2022 ANDY'S BEST CAD. ALL RIGHTS RESERVED. THIS DRAWING IS THE PROPERTY OF ANDY'S BEST CAD AND IS PROTECTED BY COPYRIGHT LAWS OF THE UNITED STATES OF AMERICA. ANY UNAUTHORIZED USE OF THE INFORMATION CONTAINED HEREIN OR PART THEREOF IS STRICTLY PROHIBITED. RECEIPT OR POSSESSION THEREOF DOES NOT CONVEY OR TRANSFER ANY RIGHT TO MAKE, COPY, MANUFACTURE AND/OR SELL EITHER THE DRAWING OR THE ITEMS SHOWN THEREIN.